


FLOOR PLAN - LEVEL 2 - AREA B

1/8" = 1'-0"

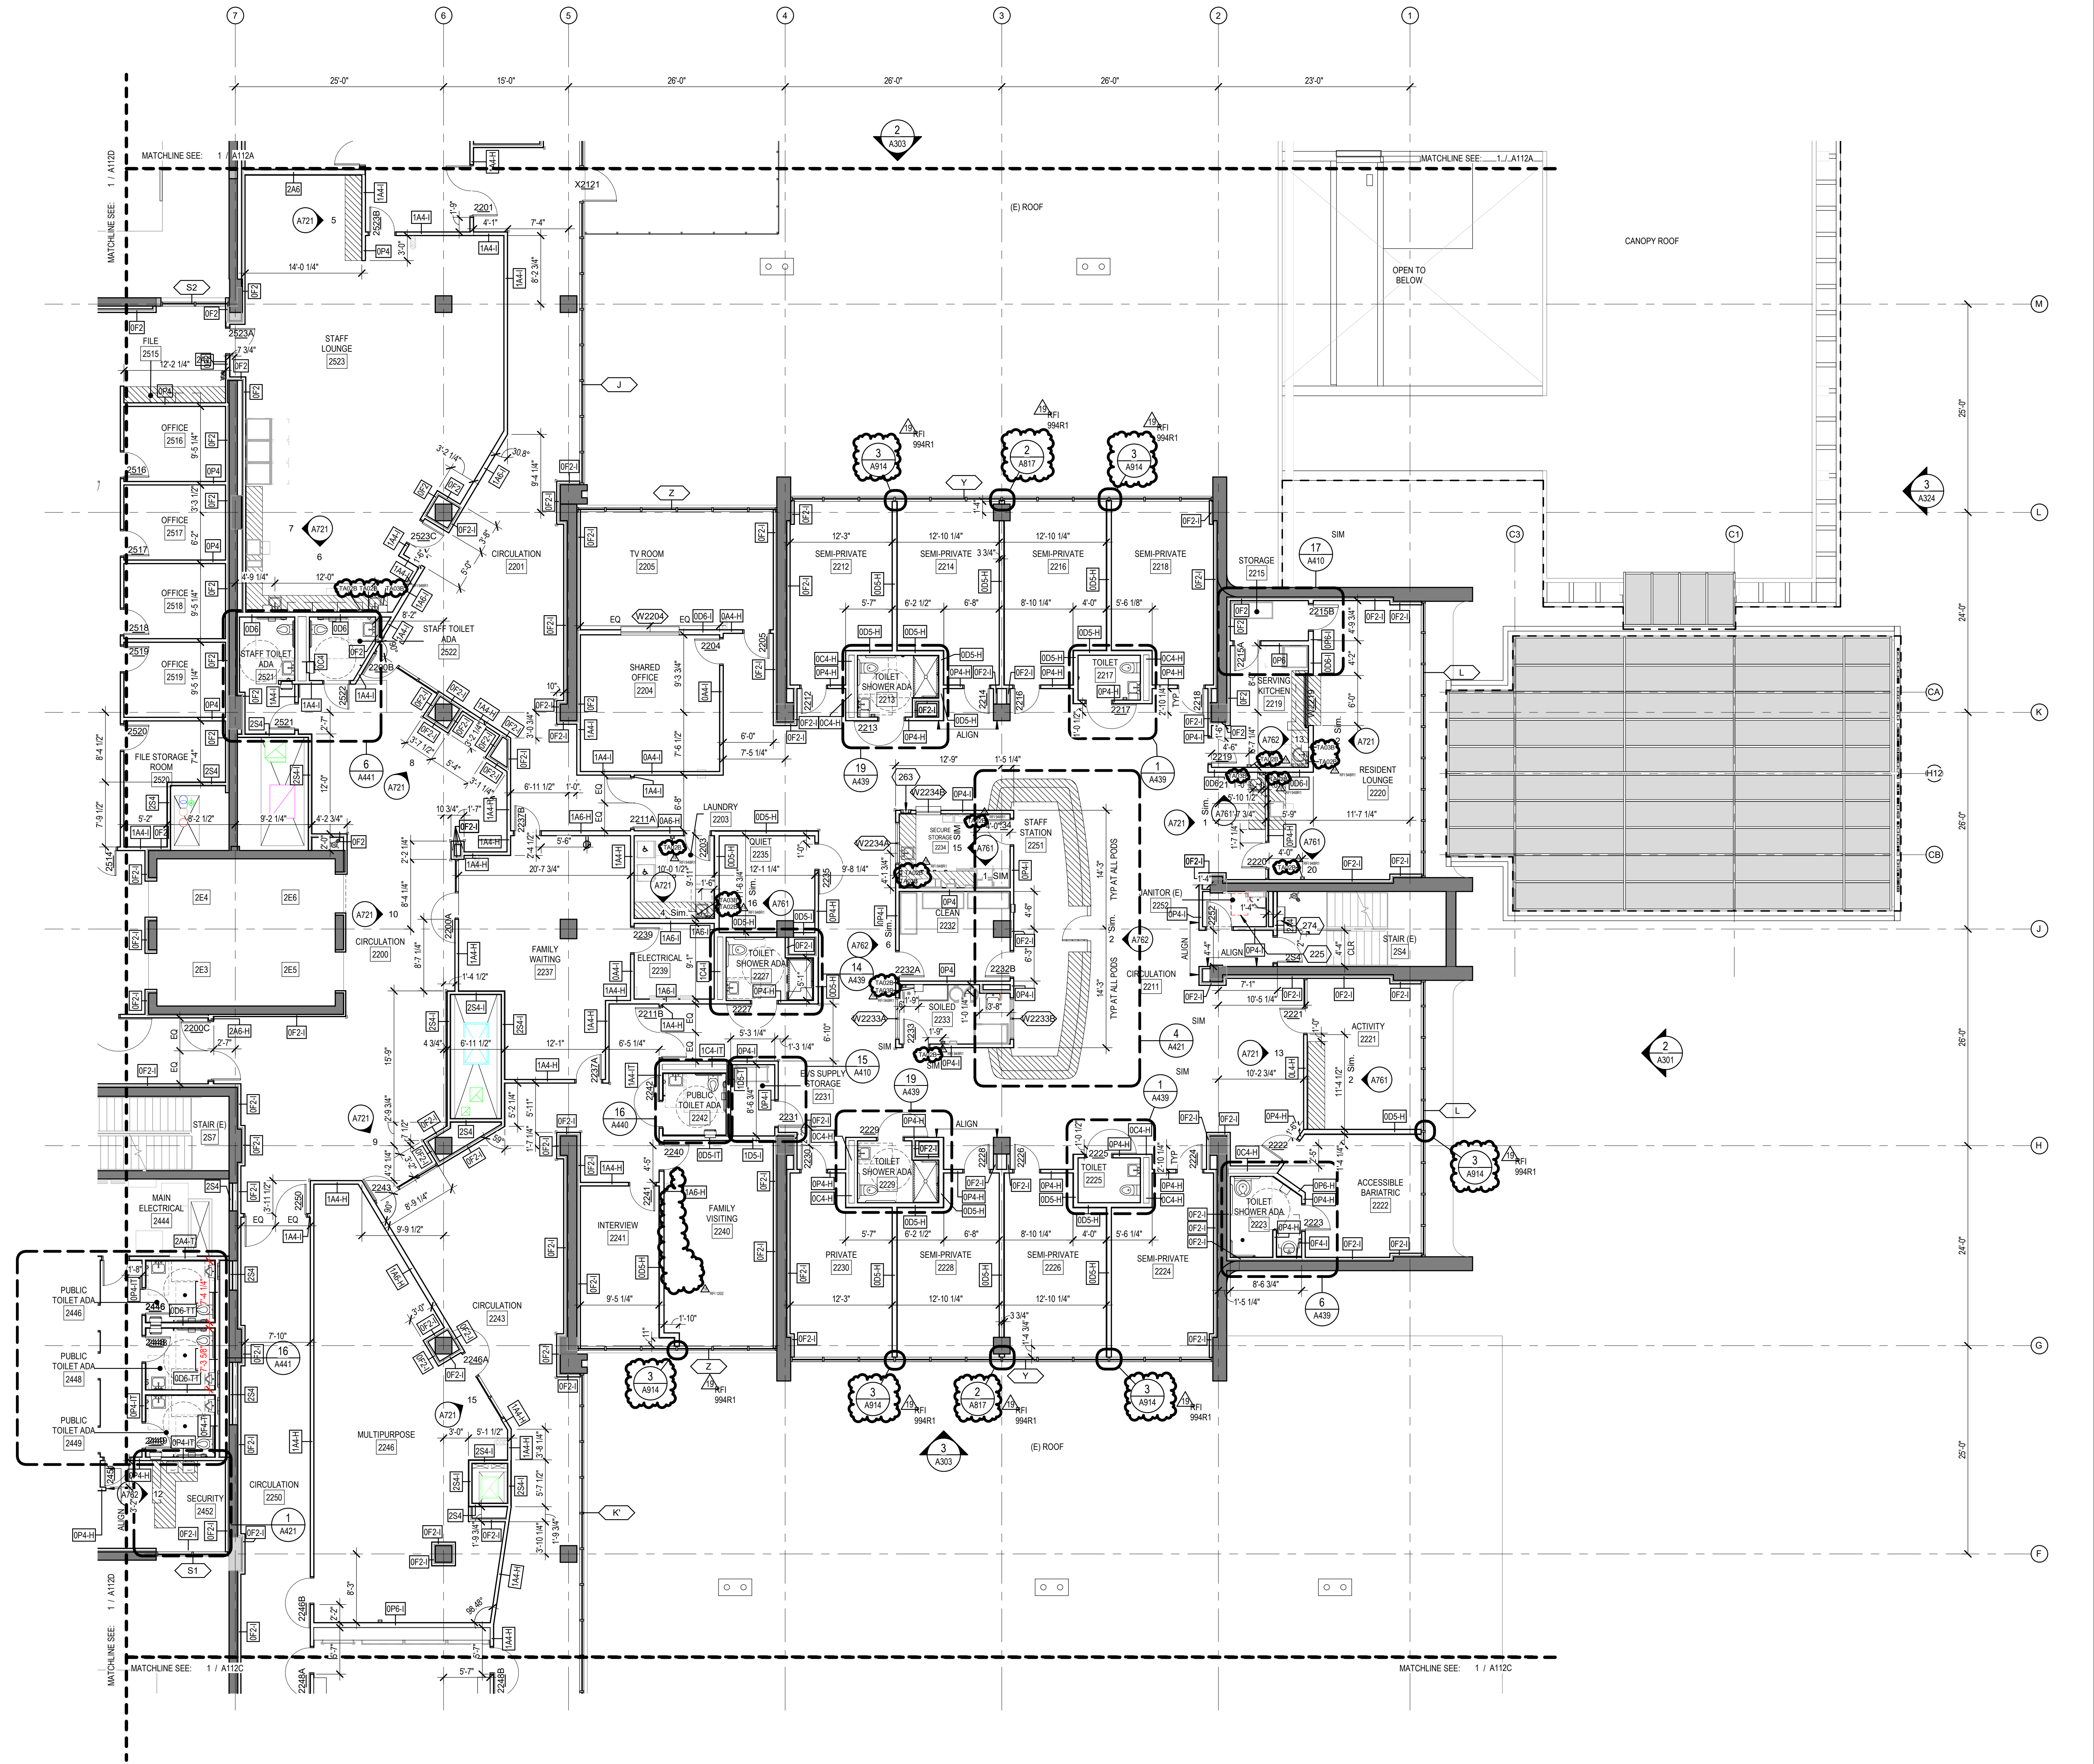

FLOOR PLAN NOTES

- SEE SHEET G-SERIES FOR ARCHITECTURAL GENERAL NOTES & SYMBOLS.
- SEE SHEETS G-SERIES FOR ACCESSIBILITY DETAILS.
- SEE LIFE SAFETY SHEETS U-SERIES SHEETS FOR DETAILED WALL RATING LEGEND.
- STRUCTURE SHOWN FOR REFERENCE ONLY. SEE STRUCTURAL SHEETS S-SERIES.
- SEE A900-SERIES FOR DOOR AND WINDOW SCHEDULE.
- SEE (SERIES (SHEETS A911-SERIES) FOR WALL PARTITION TYPES AND DETAILS.
- SEE EXTERIOR ELEVATIONS (SHEETS A300 SERIES) AND WALL SECTIONS (SHEETS A300 SERIES) FOR EXTERIOR WALL AND WINDOW INFORMATION.
- REFER TO FINISH FLOOR PLAN SERIES SHEETS FOR WALL PROTECTION LOCATIONS.
- MECHANICAL SHOWN FOR REFERENCE ONLY. SEE MECHANICAL SHEETS.
- PLUMBING SHOWN FOR REFERENCE ONLY. SEE PLUMBING SHEETS.
- ELECTRICAL SHOWN FOR REFERENCE ONLY. SEE ELECTRICAL SHEETS.
- DEPRESSED/RAISED FLOOR, SLAB OPENING AND SLAB LOCATIONS SEE CORE PACKAGE.
- SEE SHEETS Q AND QL SERIES SHEETS FOR EQUIPMENT INFORMATION.
- SEE SHEETS T SERIES FOR TELECOM INFORMATION.
- FOR KITCHEN INFORMATION, SEE SHEET FS-SERIES FOR FOOD SERVICE DRAWINGS.
- ALL FIRE EXTINGUISHER CABINETS TO BE MOUNTED TO CLEAR GUARD AND HAND RAILS.
- AT CORRIDORS, INSTALL DRYWALL CONTROL JOINT ABOVE DOORS FRAMES. REVIEW CONTROL JOINT LOCATIONS AT LONG SPAN PARTITIONS WITH ARCHITECT.
- CONTRACTOR SHALL VERIFY AND BE RESPONSIBLE FOR ALL DIMENSIONS AND CONDITIONS ON THE JOB AND SHALL NOTIFY THE ARCHITECT OF ANY VARIATIONS SHOWN BY THESE DRAWINGS.
- CONTRACTOR SHALL PROVIDE ALL REQUIRED BACKING FOR FIXTURES/EQUIPMENT, SOFFITS AND ANY OTHER SPECIAL CONSTRUCTION.
- CONTRACTOR SHALL COORDINATE ALL UNIT ELECTRICAL LAYOUTS, INCLUDING CONDUIT AND BOX PLACEMENT. EXPOSED CONDUIT AND/OR SURFACE MOUNTED BOXES WILL NOT BE ACCEPTABLE.
- CONTRACTOR TO PROVIDE & INSTALL ALL ACCESS DOORS IN WALLS & CEILINGS, WHETHER SHOWN ON THE DWGS OR NOT, WHERE REQUIRED FOR ACCESS TO LIFELINE SAFETY AND/OR MEP DEVICES, VALVES & EQUIPMENT. THE DOOR SIZE MUST BE APPROPRIATE FOR CLEAR ACCESS, AND THE LOCATIONS MUST BE SHOWN ON THE COMPOSITE COORDINATED DRAWINGS TO BE APPROVED BY THE ARCHITECT PRIOR TO INSTALLATION.
- ALL (E) INTERIOR STAIRS SHALL BE BROUGHT TO CODE COMPLIANT. REFER TO SHEET A951 FOR MODIFICATION DETAILS.
- REFER TO SHEET A130 SERIES FOR FURNITURE LAYOUT.
- REFER TO AREA PLAN FOR PARTITION TAG INFORMATION.
- ALL EXPOSED CONCRETE WALLS AND COLUMNS THAT ARE NOT SCHEDULED TO BE FURRED OUT SHALL BE PREPARED TO RECEIVE A SKIN COAT FINISH. SKIN COAT SURFACE SHALL BE FLAT AND SMOOTH AND LEVELED WITH ADJACENT PARTITION FINISH, EXCEPT WHERE EXPOSED CONCRETE WALLS AND COLUMNS OCCURRED IN AN UTILITY ROOM SUCH AS ELECTRICAL, IT, MECHANICAL, MPE, AND IDF.
- CONTRACTOR SHALL FIELD VERIFY CONDITION OF ALL EXISTING PARTITIONS LEFT FROM PREVIOUS DEMOLITION, REPAIR ANY DAMAGE AND PREPARE SUBSTRATE SURFACES TO RECEIVE FINISH PER THE FINISH SCHEDULE.
- CONTRACTOR SHALL REMOVE ALL EXISTING EXPANSION JOINT COVERS AND PREPARE EXISTING STRUCTURAL ELEMENT SURFACES FOR NEW EXPANSION JOINT COVER INSTALLATION PER NEW DETAILS.
- REFER TO SHEETS 1200-SERIES FOR INTERIOR PARTITION SCHEDULE.
- WHERE PARTITION FURRING IS SCHEDULED AT EXISTING CONCRETE WALL AND/OR CONCRETE COLUMN, THE DISTANCE FROM THE F/CONCRETE TO THE BACK SIDE F/ THE STUD FRAME SHALL BE 2" UNO.
- SACK AND PATCH CONCRETE FLOOR SLABS AT ALL DEMOLISHED HOUSEKEEPING PADS, THEN CLEAN AND SEAL AS REQUIRED.
- WHERE IN SHELL SPACES AND ELSEWHERE IN THE BUILDING, ALL ABANDONED HOLES IN EXISTING CONCRETE SLABS SHALL BE INFILLED PER STRUCTURAL REQUIREMENT.
- WHERE IN SHELL SPACES AND ELSEWHERE IN THE BUILDING, ALL ABANDONED HOLES IN EXISTING WALLS THAT HAVE A FIRE RATING REQUIREMENT SHALL BE INFILL PER STRUCTURAL AND/OR ARCHITECTURAL DETAILS TO MEET THE SAME FIRE RATING.
- WHERE ADA SHOWERS STALL IS LOCATED, REMOVE (E) TOPPING SLAB TO MATCH THE NEW STALL BOUNDARY DOWN TO SURFACE OF (E) STRUCTURAL SLAB TO ACCOMMODATE NEW WATERPROOFING AND FLOORING INSTALLATION.
- FOR FURNITURE LAYOUT REFER TO COMPOSITE FURNITURE SHEETS A130 SERIES.
- FOR LOCATION OF SMOKE CURTAIN AT ELEVATOR HOISTWAY OPENING REFER TO SHEET G010.
- ALL (N) STEEL MEMBERS SUPPORTING NEW OPENINGS IN (E) ELEVATED CONC FLOOR SLABS SHALL BE PROTECTED WITH SPRAY APPLIED FIRE PROOFING TO ACHIEVE 3-HOUR RATING. REFER TO STRUCTURAL DRAWINGS FOR FRAMING INFO AND DETAILS. REFER TO SPECIFICATION FOR FIRE PROOFING INFO.
- REFER TO LOW VOLTAGE DRAWINGS AND SIGNAGE DRAWINGS FOR ROOMS THAT HAVE BEEN IDENTIFIED TO EQUIP WITH ASSISTIVE LISTENING SYSTEM.
- NURSE CALL STATIONS SHALL BE PROVIDED AND INSTALLED IN COMPLIANCE WITH TABLE 1224.4.5 AND CCS, PART 5 OF TITLE 17. FOR ROOMS REQUIRE A NURSE CALL STATION AND DESIGN REFER TO NC-SERIES DRAWINGS IN THE ELECTRICAL SET.
- PROVIDE A 4" HIGH CONCRETE HOUSING PAD WHERE LOCKER OCCURRED.

ASSEMBLY TYPES

KEY NOTES

#	KEYNOTE DESCRIPTION
225	COPI HOUSEKEEPING CART
263	RECESSED BOTTLE FILLER
274	MED SLED & CABINET

PLUMBING LEGEND

- ANTI-LIGATURE TOILET, BARIATRIC
- ANTI-LIGATURE TOILET
- WALL-HUNG TOILET

FLOOR PLAN LEGEND

- EXISTING CONSTRUCTION TO REMAIN
- NEW CONSTRUCTION - NEW DOOR, DOOR IDENTIFIER, ASSEMBLY AS INDICATED ON DOOR SCHEDULE.
- FIRE EXTINGUISHER CABINET - FULL RECESSED
- FIRE EXTINGUISHER CABINET - SURFACE MOUNT
- VERTICAL SHAFT
- ENTRANCE GRILL EXTENTS
- HATCH DENOTES FIXED CASEWORK/ MILLWORK
- HALF-TONE GRAPHIC REPRESENT ITEMS BY OTHERS. REFER TO RESPECTIVE DESIGN DISCIPLINE DRAWINGS FOR INFO.
- FIRE EXTINGUISHER CABINET - SEMI RECESSED
- OPEN TO BELOW
- EYEWASH
- 36"x36" AREA DRAIN W/ FD IN CENTER
- HOT BOX EQUIPMENT DR-INFRARED HEATER DR-122 - SMALL



Project
MLK BEHAVIORAL HEALTH CENTER RENOVATION
12021 SOUTH WILMINGTON AVENUE
LOS ANGELES, CA 90059
COUNTY SPEC NUMBER: 7598
Prepared For
COUNTY OF LA DEPARTMENT OF PUBLIC WORKS
900 SOUTH FREMONT AVENUE
ALHAMBRA, CA 91803



Hellmuth, Obata & Kassabaum, Inc.
9530 Jefferson Boulevard
Culver City, CA 90232 USA
t+1 310 838 9555 f+1 310 838 9586



Bernards
Design - Builder
555 First Street
San Fernando, CA 91360
All structural and mechanical property rights reserved © 2019
In Association with
VCA Engineers, Inc. - Civil Engineer
1041 S. Garfield Ave, Suite #210
Alhambra, CA 91801
John A Martin & Associates
Structural Engineer
950 South Grand Avenue
Los Angeles, CA 90015

P2S Inc. - MEPT Engineers
5000 E. Spring Street, Suite 800
Long Beach, CA 90815

AVS Engineers, Inc. - Security Electronics
981 Corporate Center Dr., Ste. 108
Pomona, CA 91768



SKA Design - Signage/Wayfinding
900 Palm Avenue
South Pasadena, CA 91030

Mazzetti + GBA - Medical Equipment
393 Nichol Mill Lane, Suite 150
Franklin, TN 37067

WC&P - Food Services
1000 Fourth Street
San Rafael, CA 94901

St. Onge - Materials Management
1400 Williams Road
York, Pennsylvania, 17402

Coffman Engineers - Life Safety
16133 Ventura Boulevard, Ste. 1010
Encino, California 91436

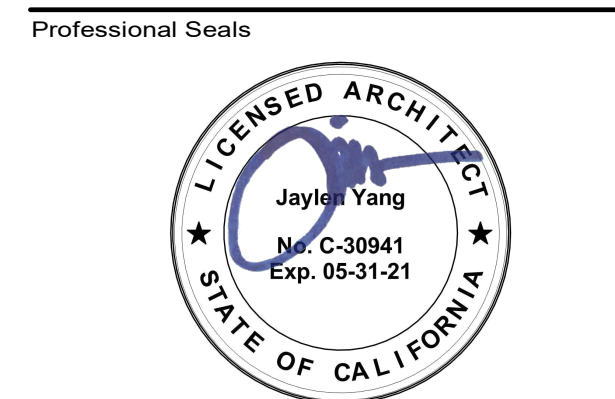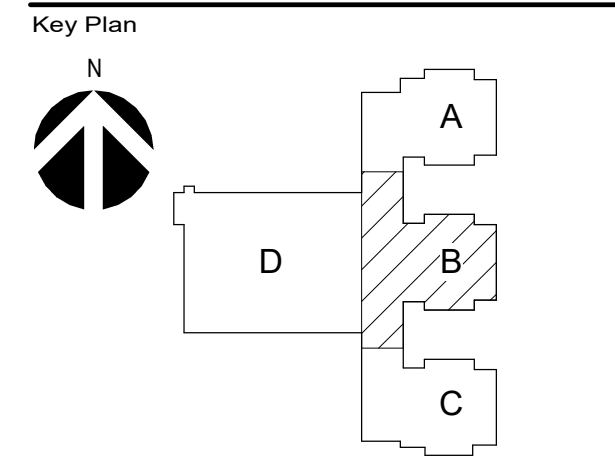





No.	Description	Date
2	1150% CD	11/22/2019
3	TI PERMIT SET	12/20/2019
4	NOT USED	
5	FD REVIEW	01/16/2020
6	UG REVIEW AND APPROVAL	01/17/2020
7	TI 1ST BACKCHECK	02/14/2020
8	FD 1ST BACKCHECK	02/20/2020
9	IFC CANC.	03/09/2020
10	TI 2ND BACKCHECK	03/02/2020
11	FD 2ND BACKCHECK	04/03/2020
12	FOR IFC	04/06/2020
13	BULLETIN 1	05/09/2020
14	FD APPROVAL	06/04/2020
15	B3 FM & DESIGN COORD & RFI	07/06/2020
16	B4 LIGATURE RESIST CONFORM	07/10/2020
17	B5 COORD & RFI REV - CP & TI PACK	07/24/2020
18	B7 DESIGN UPDATE & RFI	11/13/2020
19	B9 FLS CHANGES & RFI	03/05/2021

Project No: 19.24004.00
Sheet Title

FLOOR PLAN - LEVEL 2 - AREA B

Original is 42" x 30". Do not scale contents of this drawing.
Sheet Number

A112B

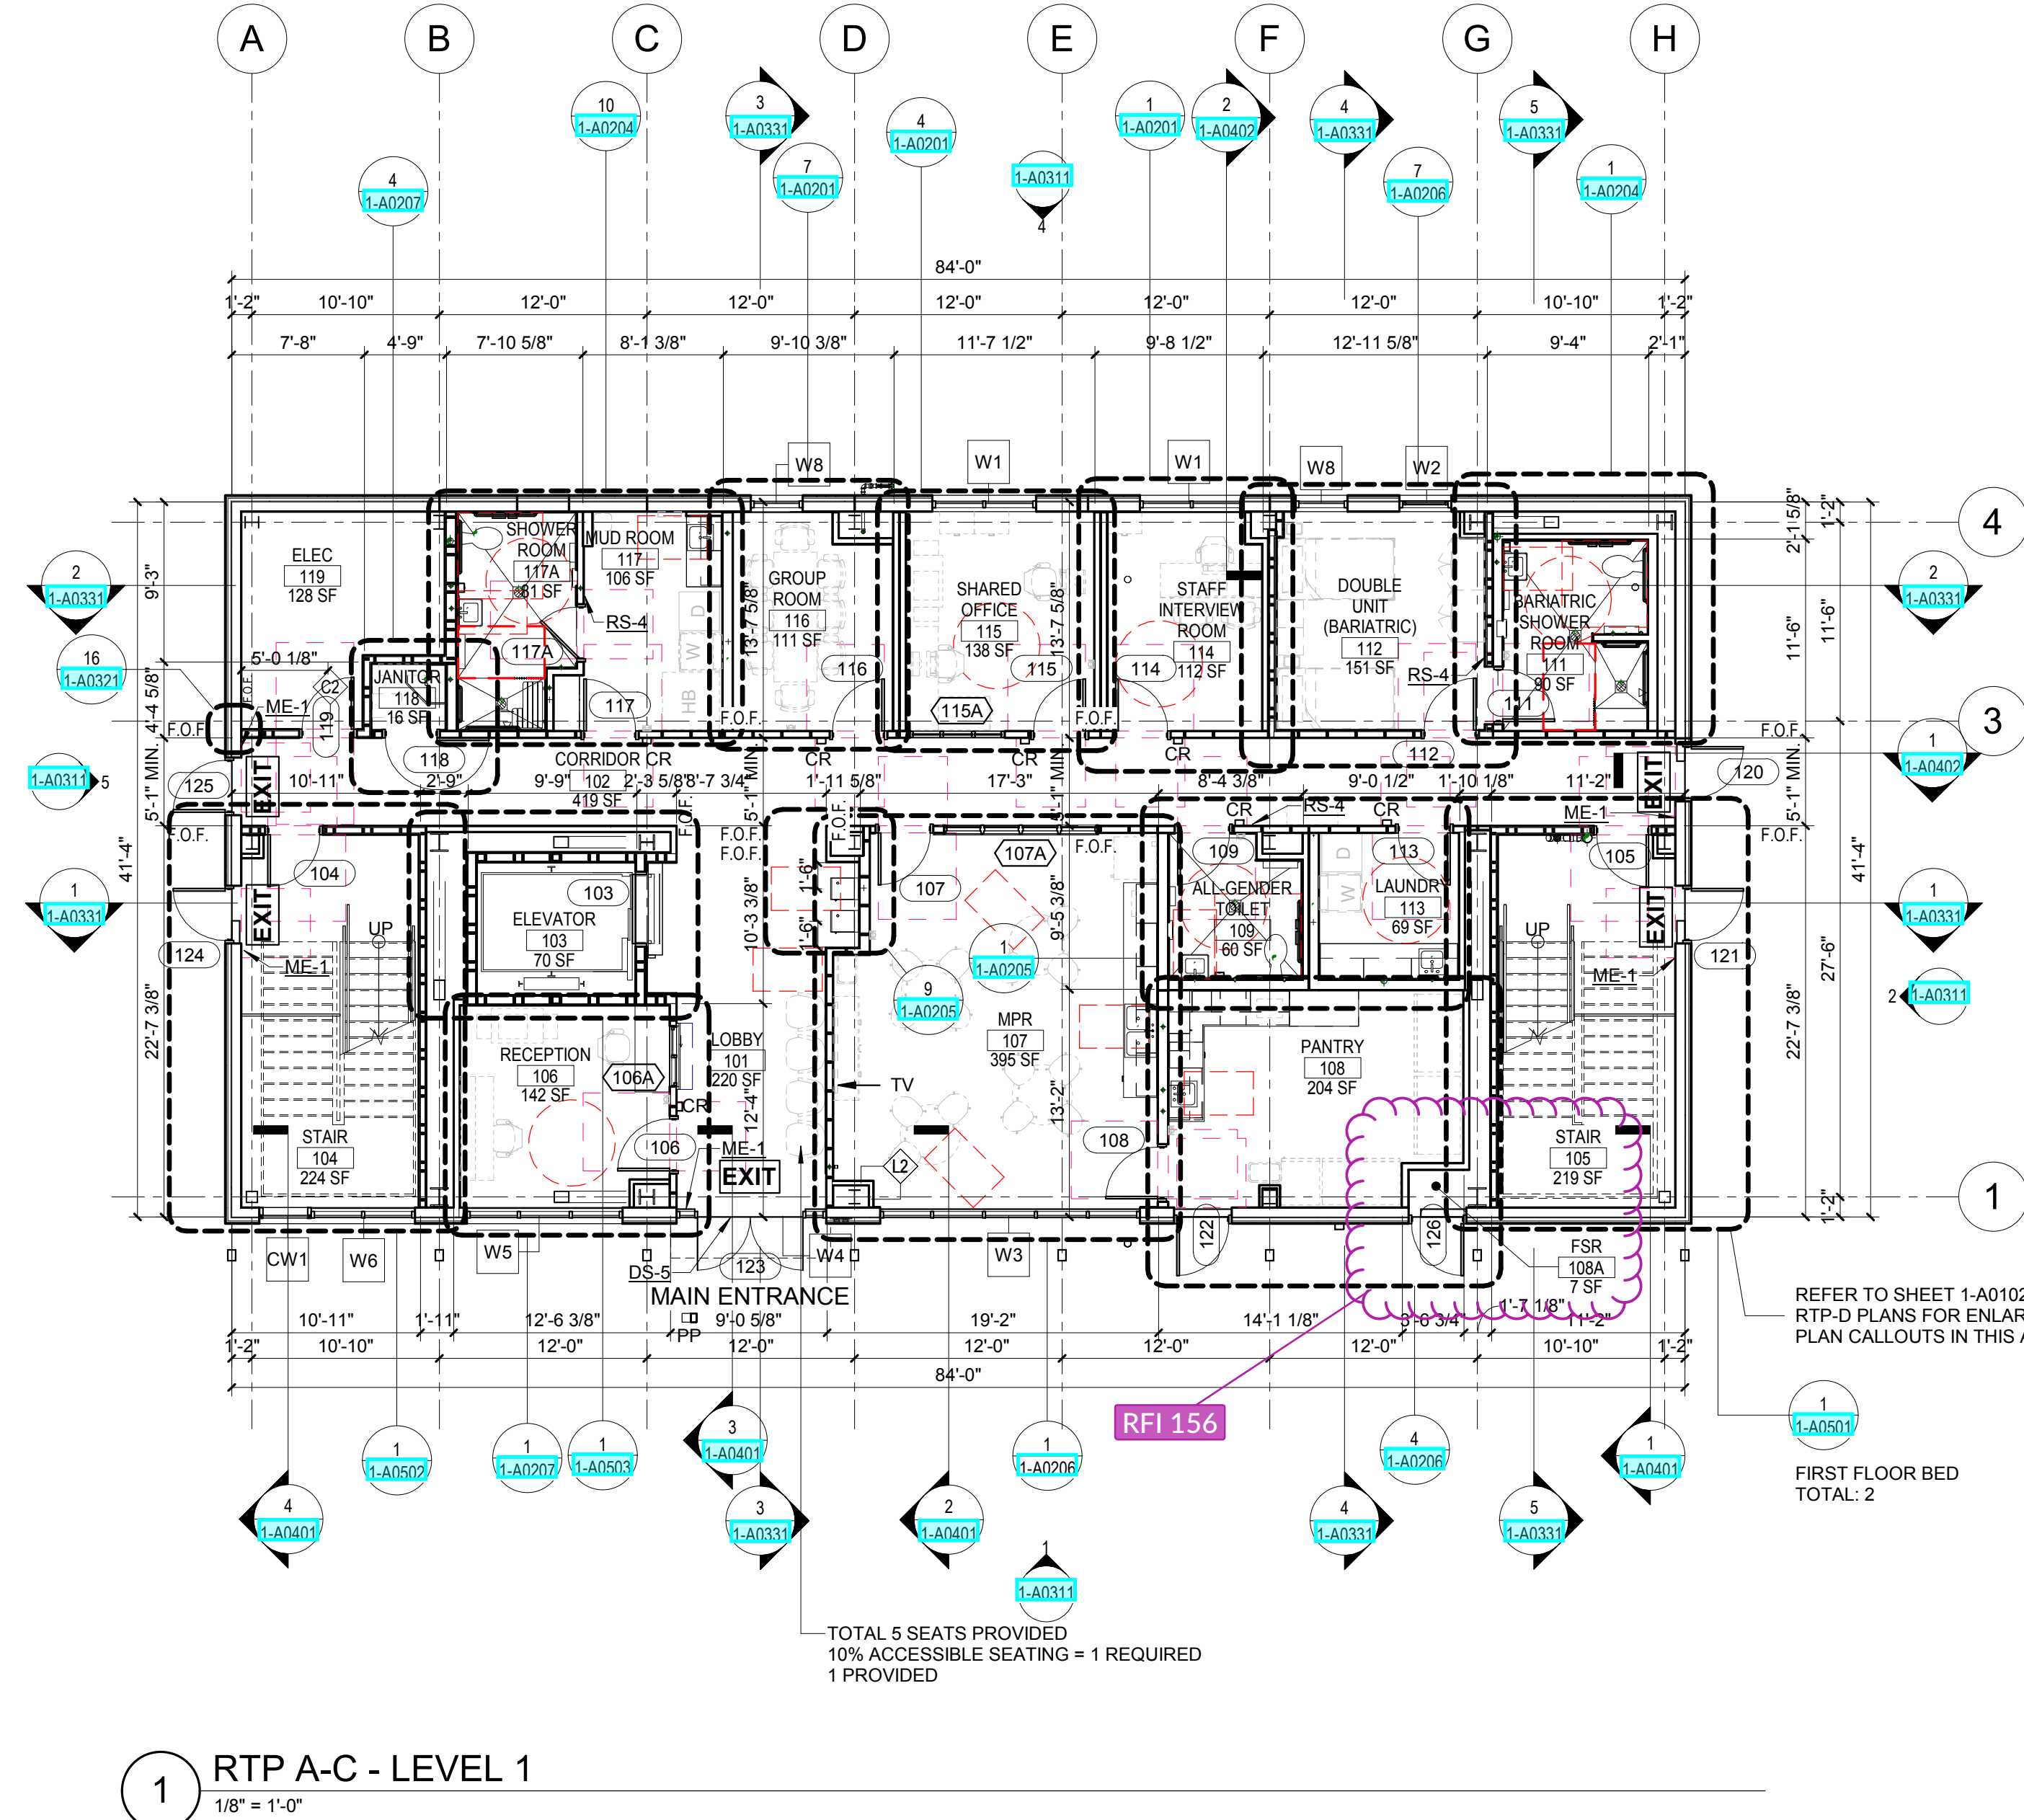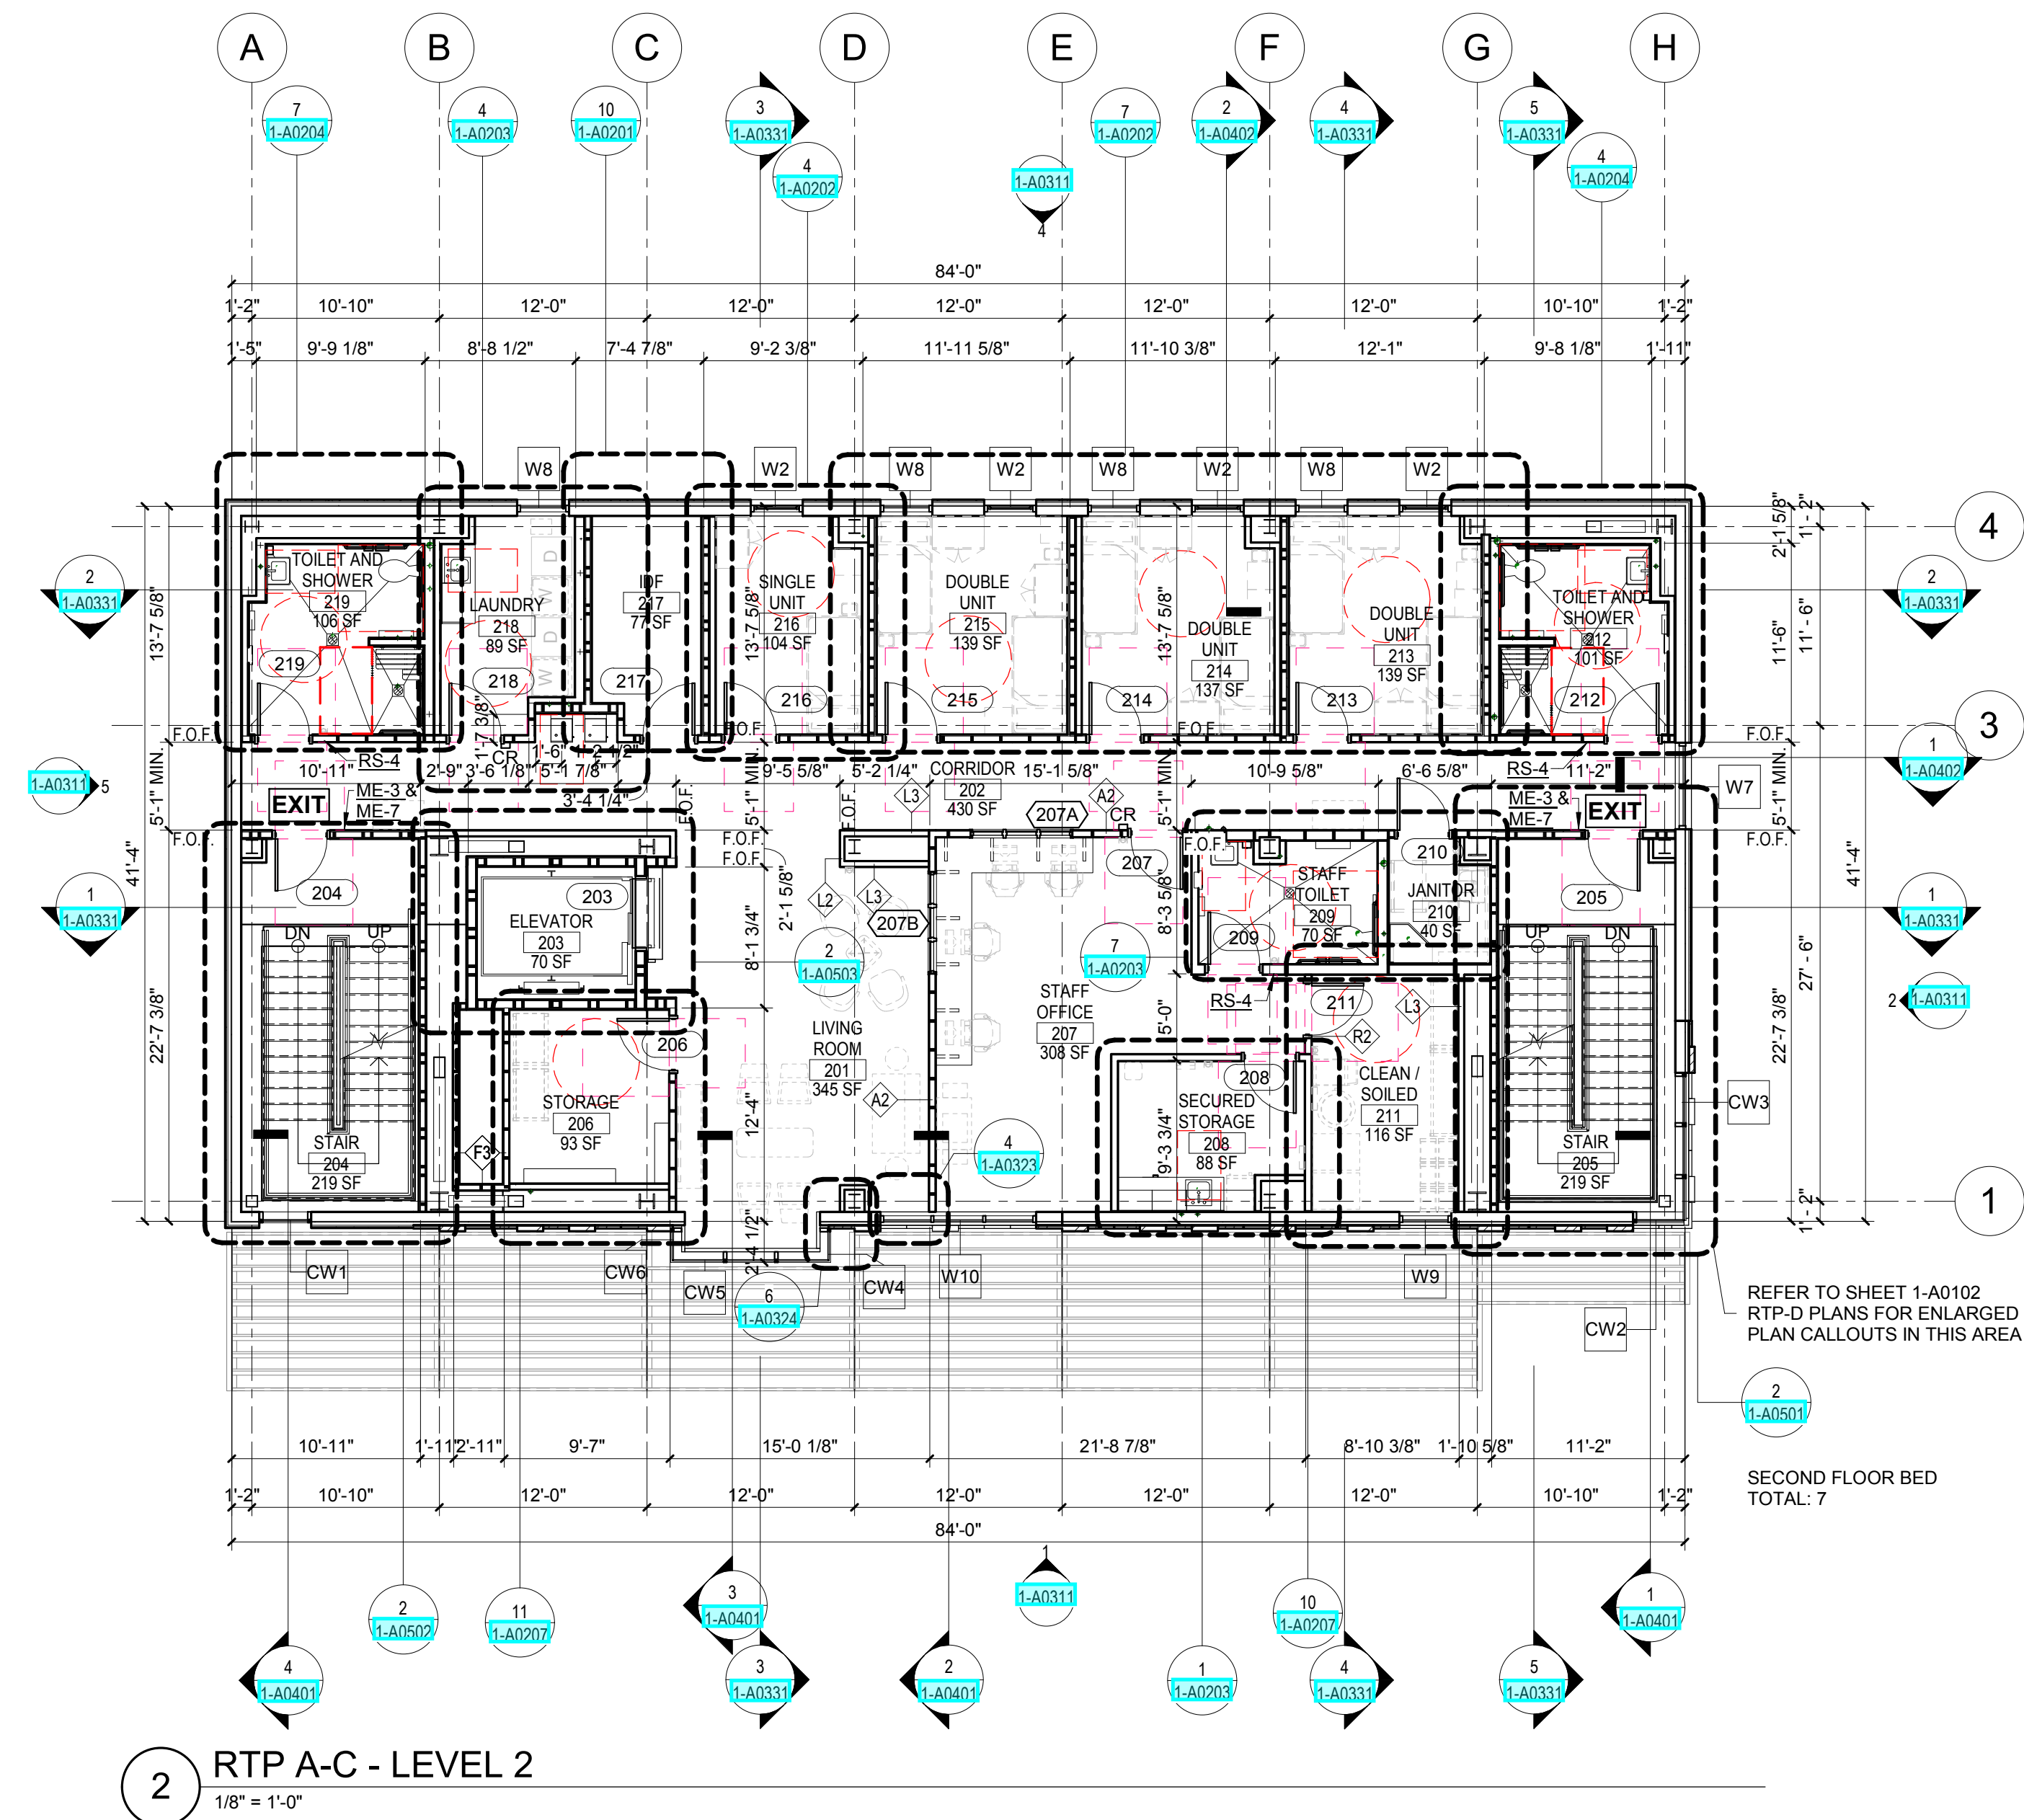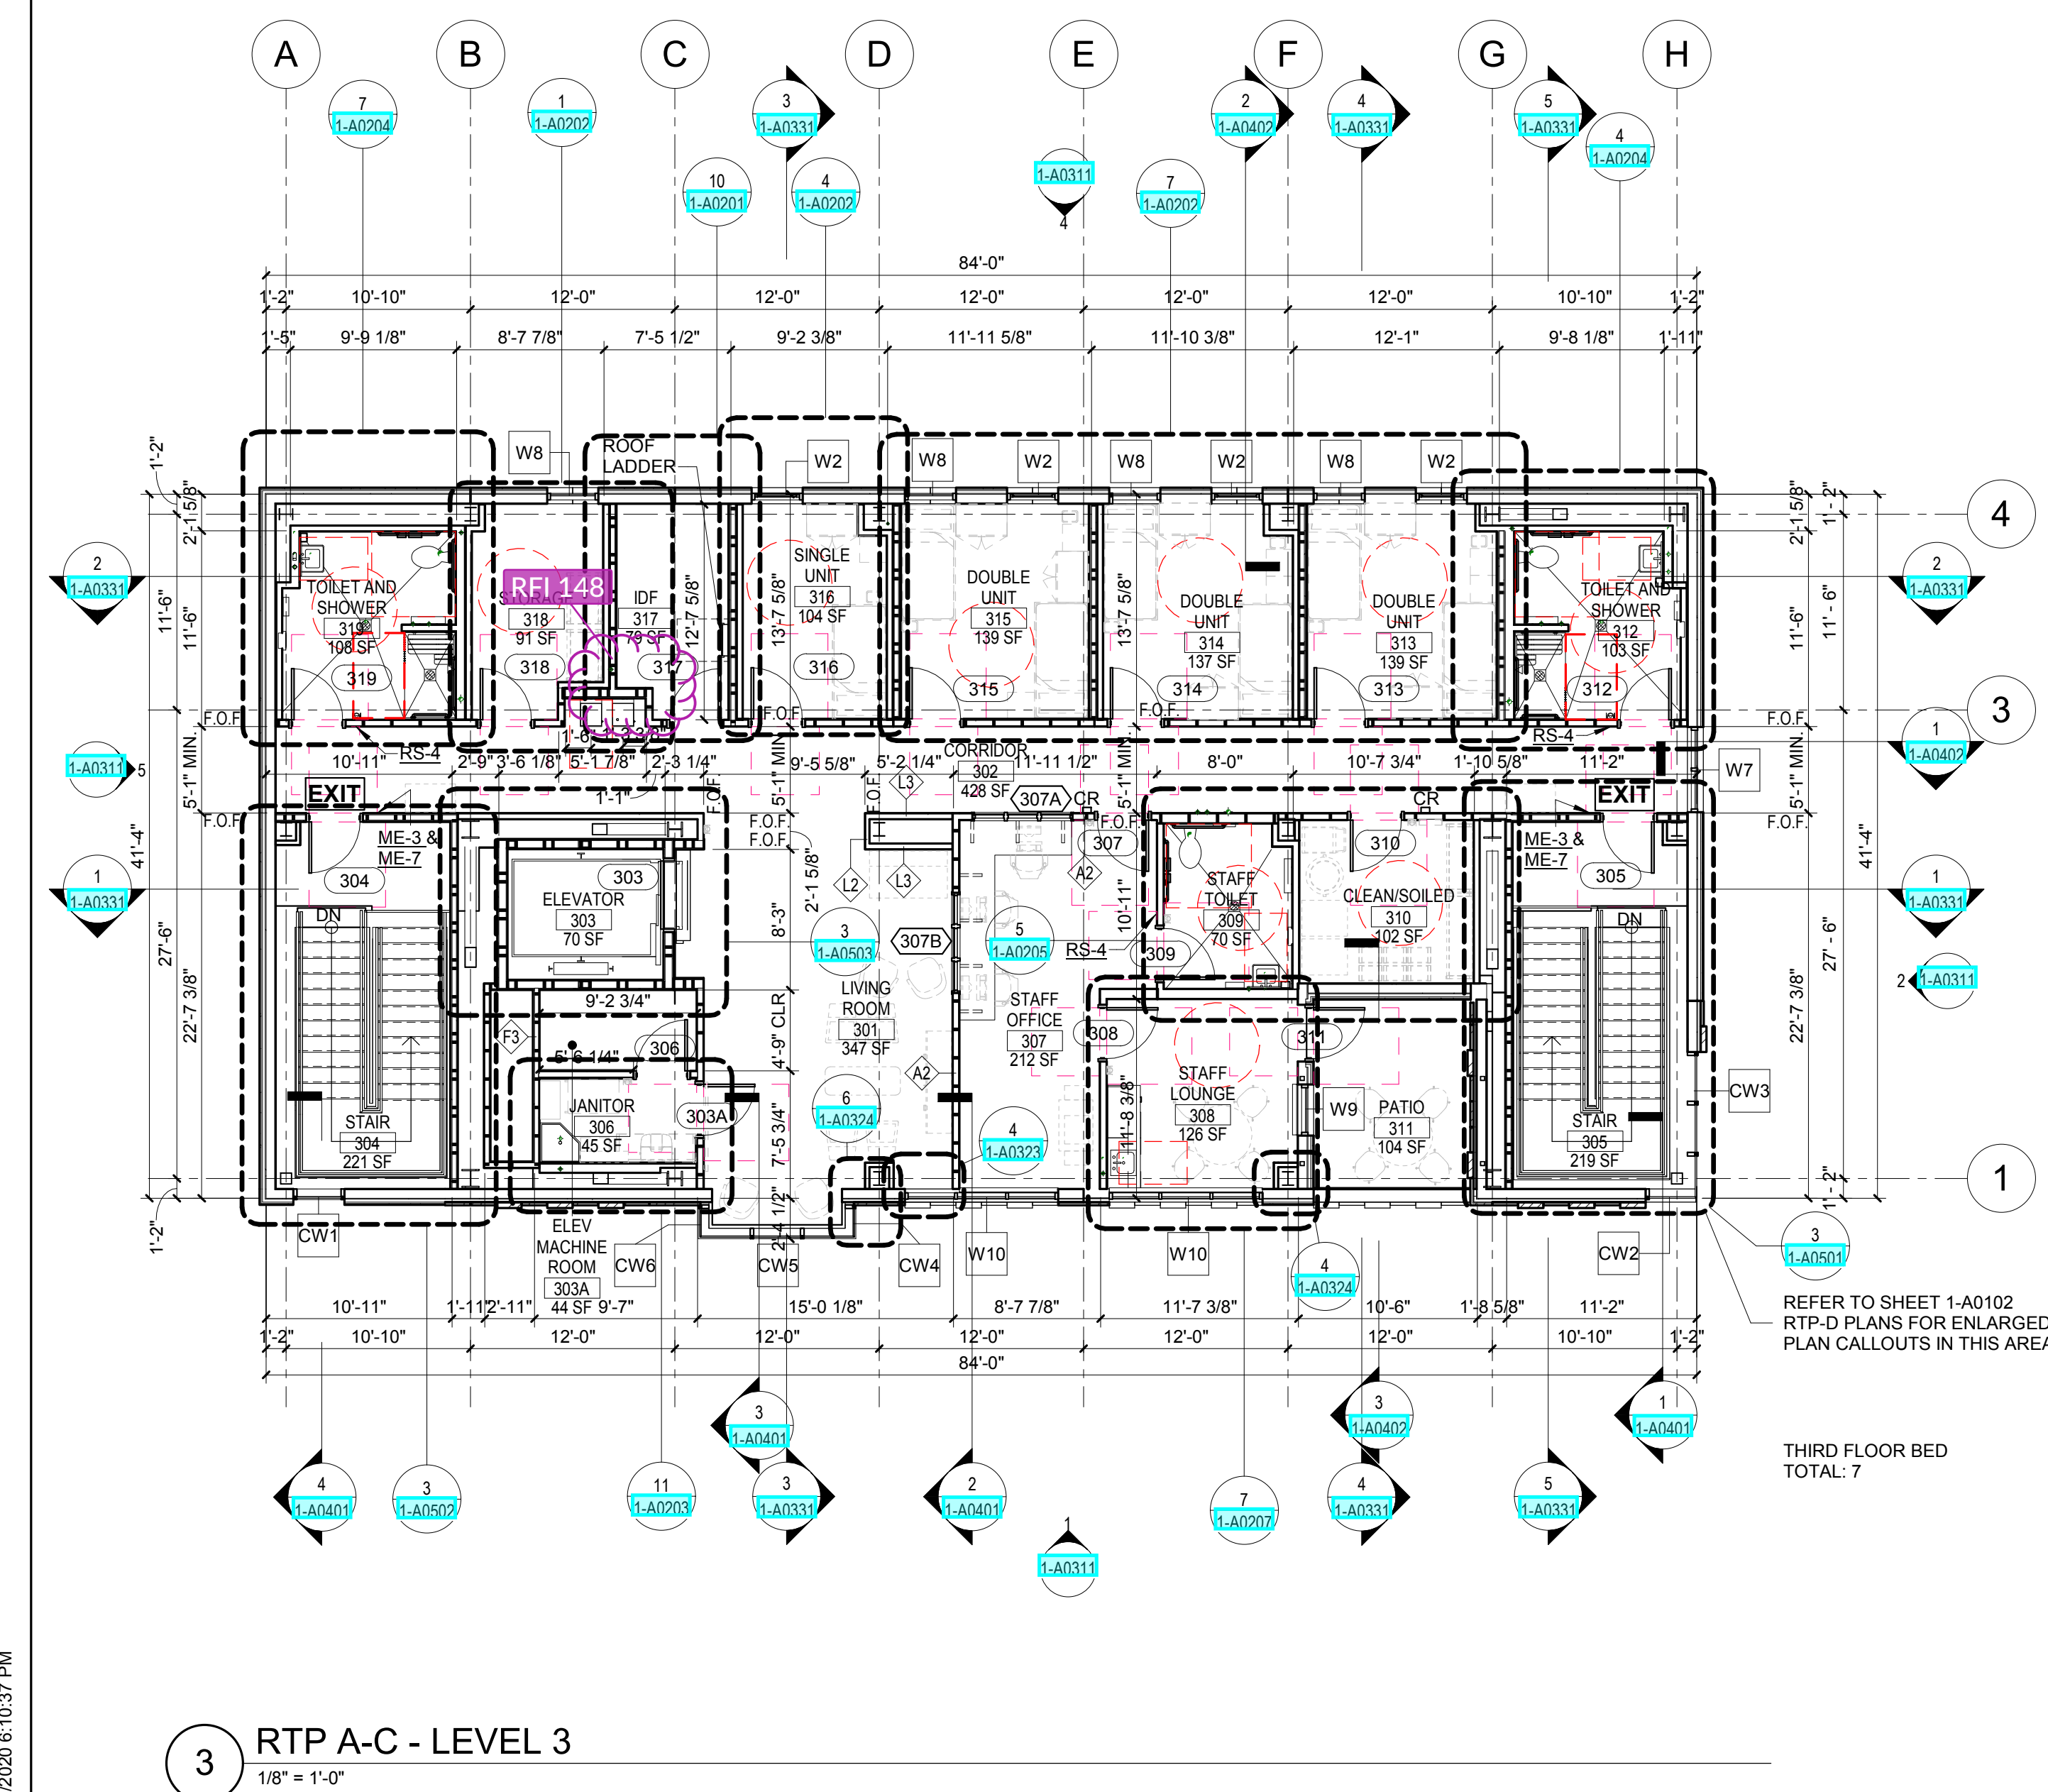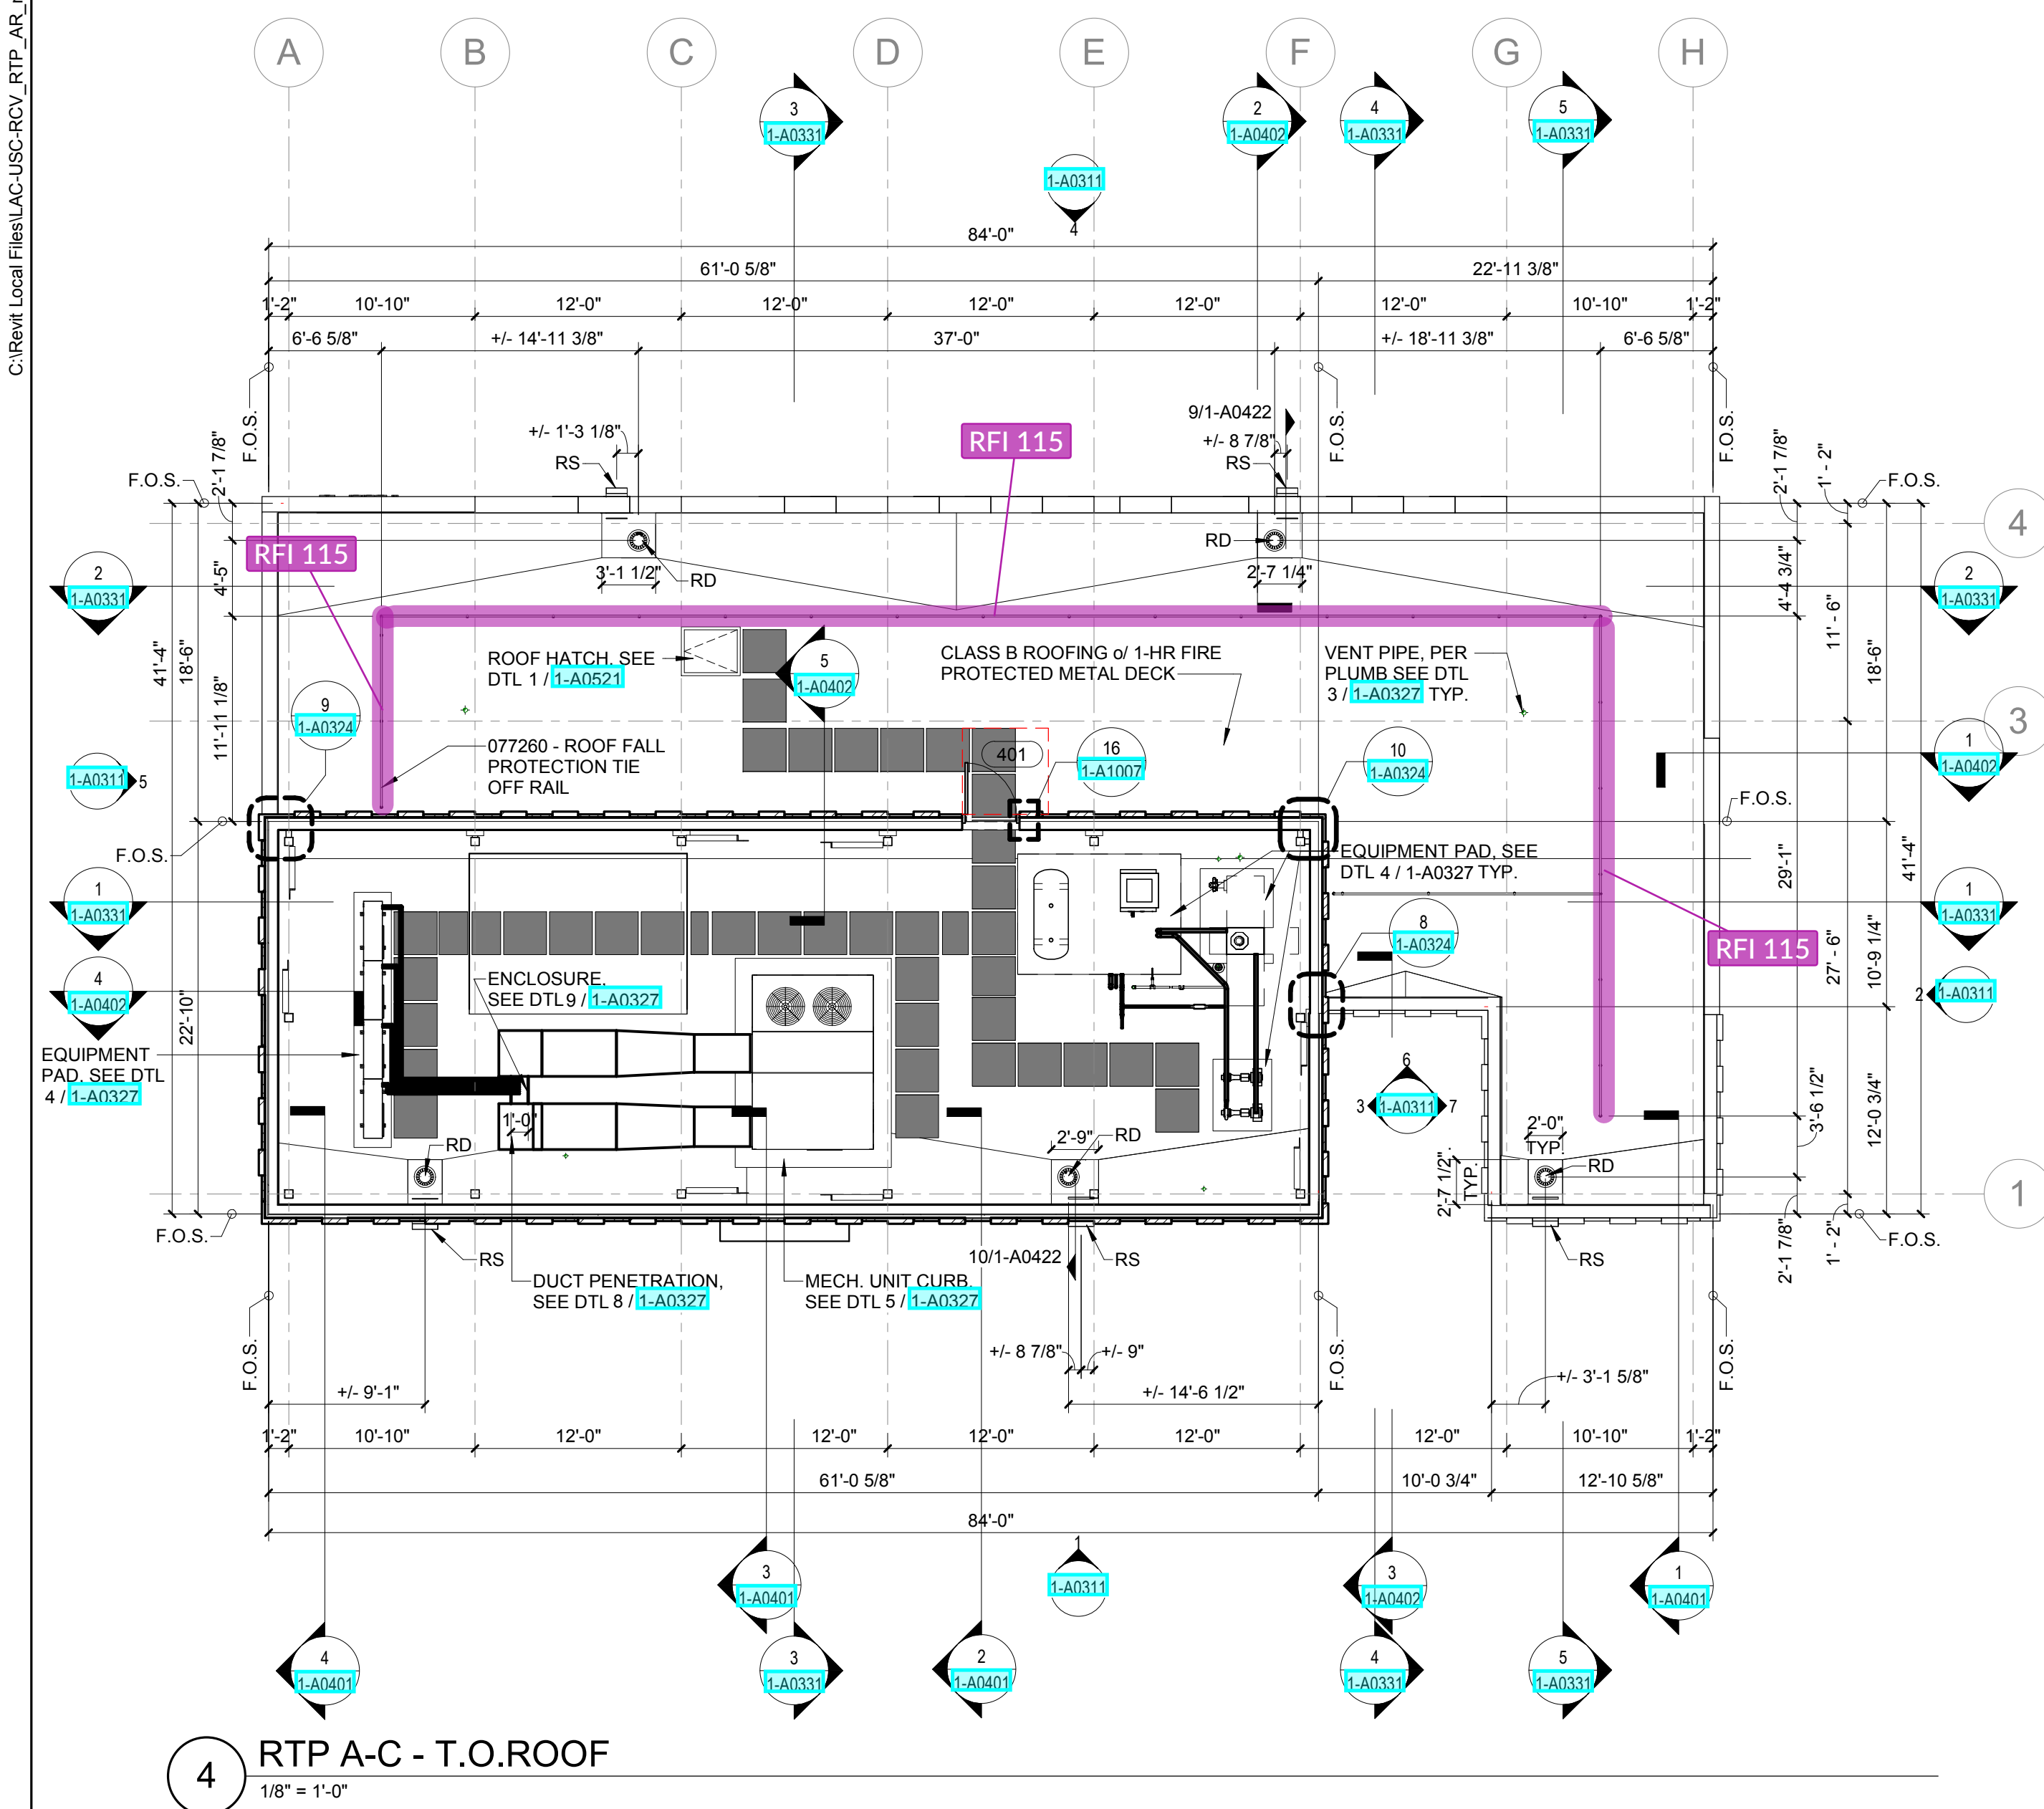

GENERAL NOTES

- ALL WINDOWS, STOREFRONT AND CURTAIN WALL SYSTEMS SHALL HAVE WINDOW COVERINGS. ALL WINDOW COVERINGS AND ASSOCIATED OPERATING DEVICES SHALL BE LIGATURE-RESISTANT.
- WINDOW, STOREFRONT AND CURTAIN WALL SYSTEM TYPE NUMBERS APPLICABLE TO ALL BUILDINGS WITHIN PROJECT.
- FOR GLAZING TYPES, SEE EXTERIOR GLAZED OPENINGS SHEETS 1-A0101.
- REFER TO SHEETS 1-A0101 & 1-A0102 FOR PARTITION TYPES AND NOTES, INCLUDING STC RATINGS, ALL SLEEPING ROOM WALLS TO HAVE MINIMUM STC 50. CONCRETE SLAB ON METAL DECK ALL FLOORS - MINIMUM IIC 50.
- PROVIDE CONTINUOUS FIRE RATED CONSTRUCTION AROUND ALL RECESSED FIXTURES LOCATED IN FIRE RATED PARTITIONS.
- PROVIDE TYPE A INSULATION ALONG ALL EXTERIOR WALLS, U.O.N. INSULATION TO FILL ENTIRE CAVITY.
- PROVIDE BACKING PLATES FOR ALL N.I.C. AND O.F.C.I., O.F.V.I., O.F.O.I., V.F.V.I., V.F.C.I. WALL AND FLOOR MOUNTED EQUIPMENT. REFER TO INTERIOR ELEVATIONS, CASEWORK, EQUIPMENT AND SIGNAGE FOR TYPES AND LOCATIONS. REFER TO STRUCT DRAWINGS FOR BACKING REQUIREMENTS.
- REFER TO E.O.S. PLANS FOR SLAB DEPRESSIONS.
- REFER TO ELECTRICAL DRAWINGS FOR EXIT SIGNS AND EMERGENCY EXIT LIGHTING.
- ALL SLEEPING ROOMS TO HAVE SMOKE AND CARBON MONOXIDE ALARMS. REFER TO ELECTRICAL PLANS.
- FOR RATED PARTITIONS THAT TERMINATE OR INTERRUPTED BY COLUMNS AND NOT IDENTIFIED BY SPECIFIC DETAIL, REFER TO DETAIL 1-A0205.
- REFER TO SHEETS 1-A0101 & 1-A0102 FOR ACCESSORY MOUNTING HEIGHTS AND ACCESSIBILITY COMPLIANCE NOTES AND DETAILS.
- REFER TO SHEET 1-A0102 FOR FLOOR AND ROOF PLANS OF RTP-D BUILDING.

SHEET LEGEND

WALL RATING LEGEND

- NON-RATED PARTITION (REFER TO PARTITION TYPES T, P, L, S, N, K, R, M, J)
- 1-HR FIRE RATED PARTITION (REFER TO PARTITION TYPES A, B, H, MD1, MD2)
- 2-HR RATED FIRE PARTITION (REFER TO PARTITION TYPES C, MD3, MD4)
- 2-HR RATED FIRE BARRIER (SHAFT & STAIR WALLS, OCCUPANCY SEPARATION (REFER TO PARTITION TYPES G))

SYMBOL LEGEND

- F.E.C. FIRE EXTINGUISHER CABINET AND EXTINGUISHER
- F.O.S. FACE OF STUD
- F.O.F. FACE OF FINISH
- ME-1 MEANS OF EGRESS SIGNAGE ME-#, SEE DETAIL 4 / 1-A0403
- RS-1 ROOM SIGNAGE RS-#, SEE DETAIL 15 / 1-A0404
- DS-5 PROVIDE 1" HIGH LETTERING STATING THIS DOOR TO REMAIN UNLOCKED WHEN BUILDING IS OCCUPIED.
- INTERIOR WALL PARTITION TYPE - REFER TO SHEETS 1-A0101 & 1-A0102
- DOOR IDENTIFICATION
- WINDOW TYPE
- LOUVER TYPE
- EQUIPMENT IDENTIFICATION
- D.S. DOWNSPOUT
- RD ROOF DRAIN, SEE DETAIL 1 / 1-A0327
- RS ROOF SCUPPER, SEE DETAILS 9 / 1-A0422 & 10 / 1-A0422
- AD AREA DRAIN
- PA PLANTER AREA - SEE LANDSCAPE DWGS.
- FD FLOOR DRAIN - SEE PLUMBING DWGS.
- WH WATER HEATER - SEE PLUMBING DWGS.
- FSR FIRE SPRINKLER RISER PER PLUMB. DWGS.
- W.C.L. WINDOW CENTER LINE
- DF DRINKING FOUNTAIN
- CG CORNER GUARD
- E.J. E.J. EXPANSION JOINT (TYP.) SEE NOTE: PROVIDE EXPANSION JOINT AT ALL EXTERIOR WALLS, PLANTER WALLS, OF ALL EXTERIOR WALLS, PLANTER WALLS, CONCRETE BENCHES, CONCRETE CURBS AND RAILING WALLS, TYPE PER DETAIL 1-A0101 & 1-A0102. THIS APPROVED DRAWING SHALL BE KEPT ON THE CONSTRUCTION PREMISES AT ALL TIMES DURING WHICH THE WORK AUTHORIZED IS IN PROGRESS AND SHALL BE OPEN TO INSPECTION BY PUBLIC OFFICIALS.
- C.J. CONTROL JOINT
- EQUIPMENT REFER TO EQUIPMENT SCHEDULES ON SHEETS 1-A0101 TO 1-A0103
- FURNITURE, O.F.O.I.
- 5'-0" DIA. ACCESSIBLE TURNING CLEARANCE
- 30" X 48" ACCESSIBLE WHEELCHAIR CLEARANCE
- ACCESSIBLE DOOR CLEARANCE
- FIRE HYDRANT PER CIVIL DWGS.
- CARD READER
- PUSH PLATE



LAC + USC
RESTORATIVE CARE VILLAGE
1774 ZONAL AVENUE
LOS ANGELES, CA 90033

CANNONDESIGN

444 South Flower Street, Suite 4700
Los Angeles, CA 90071
P: 310.229.2700

www.cannondesign.com

OWNER
LA COUNTY DEPARTMENT OF PUBLIC WORKS
900 S. Fremont Avenue
Alhambra, CA 91803
626-300-2343

CIVIL
CORNERSTONE LAND SURVEYING INC.
20730 Knob Place
Perris, CA 92570
951-736-0200

LANDSCAPE
RELM
617 S. Olive Street, Suite 1110
Los Angeles, CA 90014
213-233-2837

STRUCTURAL
CANNONDESIGN
444 South Flower Street, Suite 4700
Los Angeles, CA 90071
310-229-2700

MECHANICAL
SOUTHLAND ENGINEERING
12131 Western Avenue
Garden Grove, CA 92641
714-901-5800

ELECTRICAL
RANDALL LAMB ASSOCIATES, INC.
4757 Palm Avenue
La Mesa, CA 91942
619-713-5700



ARCHITECT OF RECORD
NUMBER

PLAN CHECK SUBMITTAL 24 JULY 2020
Rev. Description Date

C B RTP BLDGS A-C

A A RTP BLDG D


B B RTP BUILDINGS

Drawing Title:

FLOOR & ROOF PLANS

Project No.: 280054.00 Checked by: Checker

1-A0101

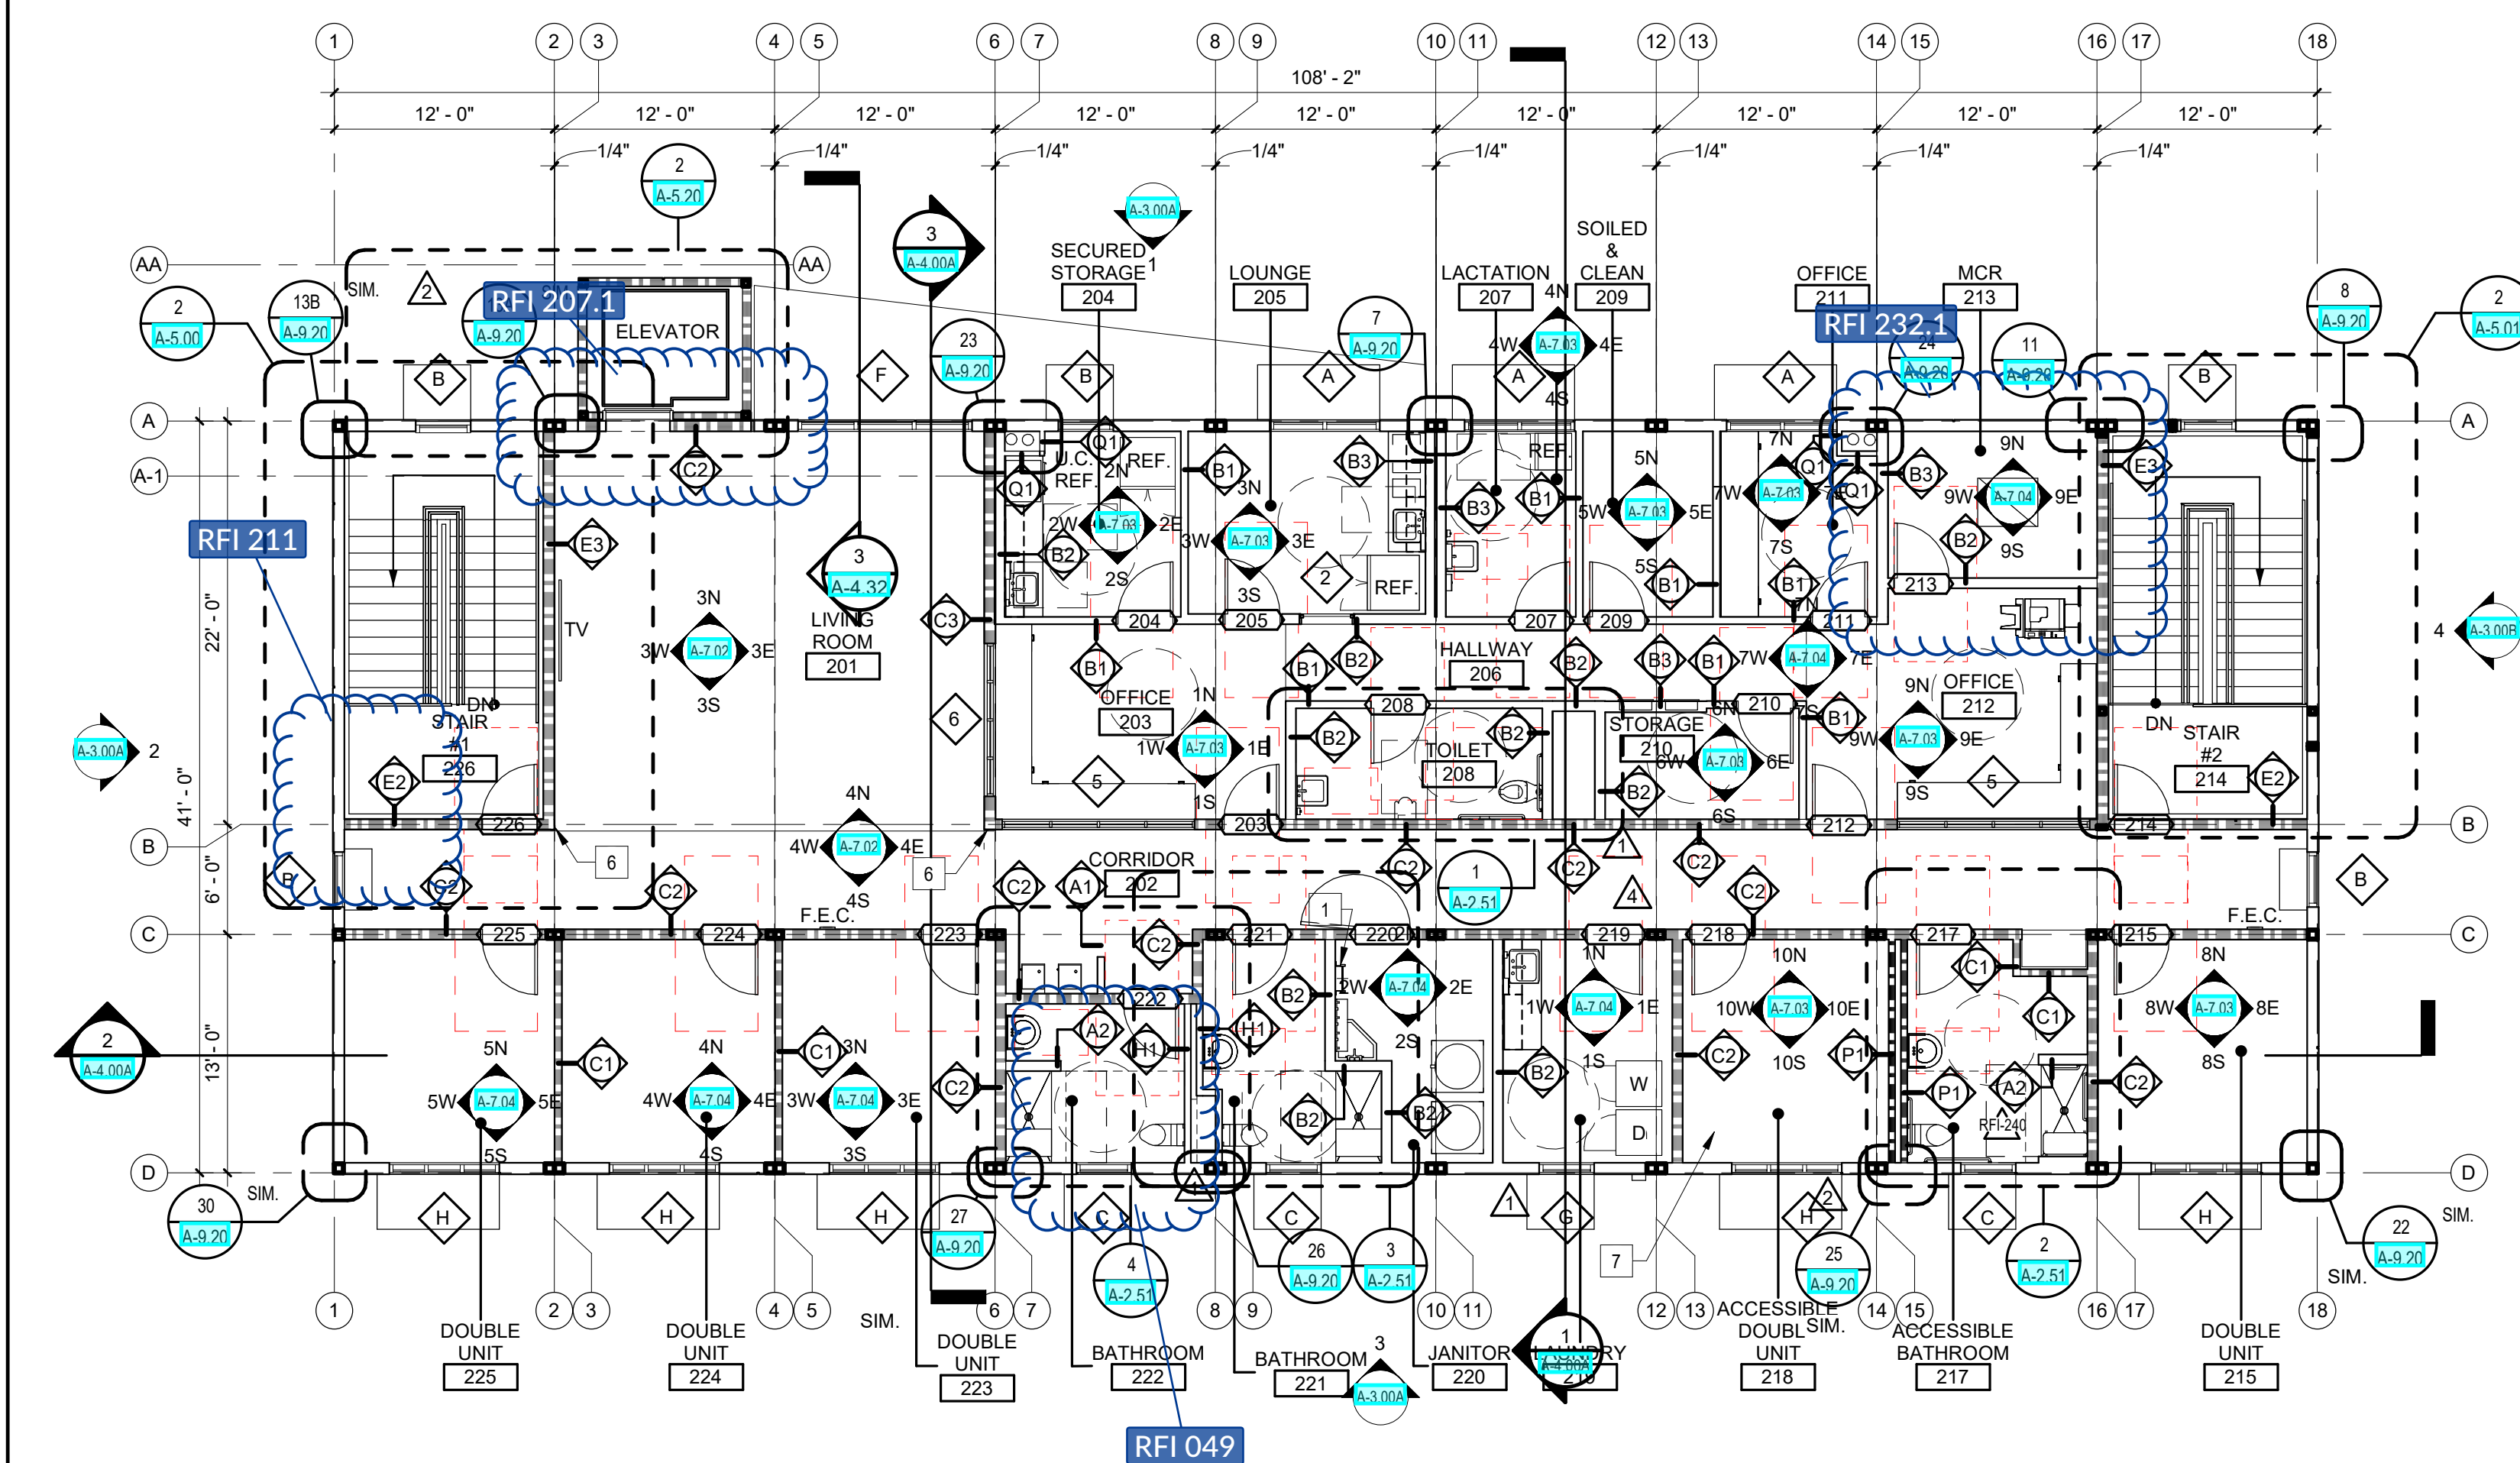


4,520 GSF

RTP A - SECOND FLOOR PLAN

1/8" = 1'-0"

2

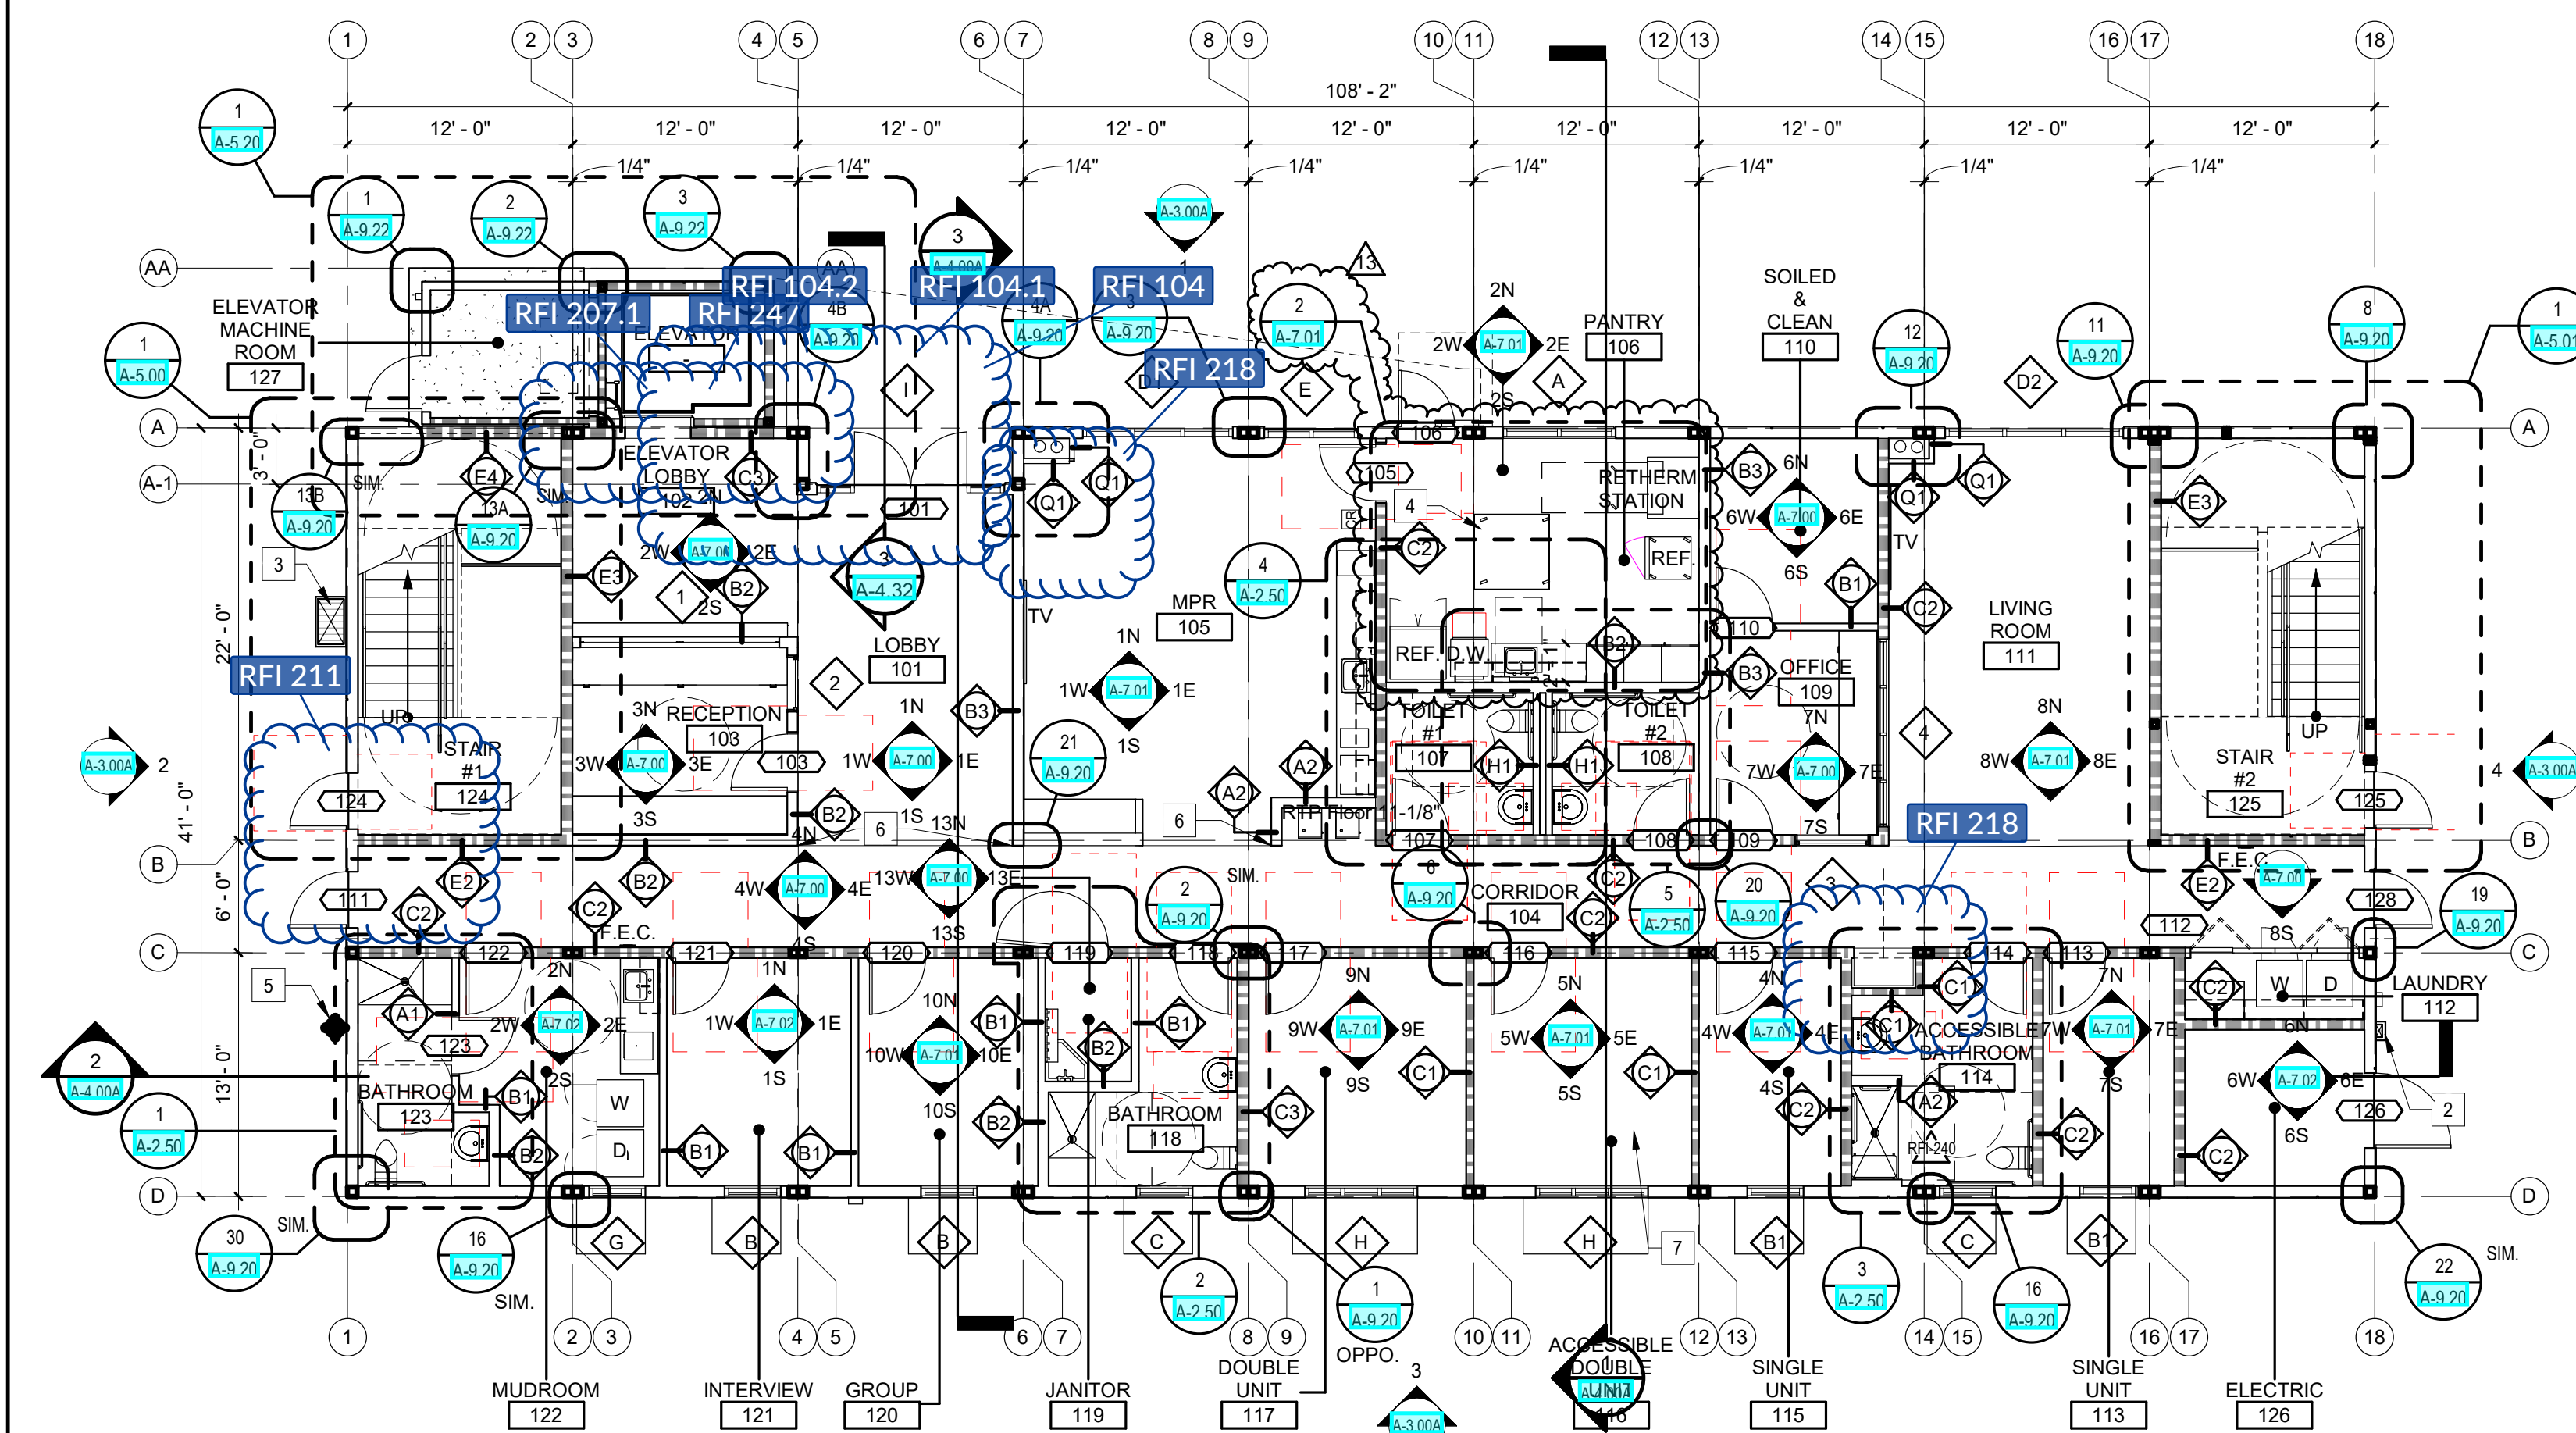

4,588 GSF

RTP A - FIRST FLOOR PLAN

1/8" = 1'-0"

1

KEYNOTES - OVERALL FLOOR PLANS

1. ROOF LADDER. REFER TO DETAIL 6A.7.50.
2. CRAWL SPACE VENT. REFER TO DETAIL 23A.4.31 AND STRUCTURAL DRAWINGS.
3. CRAWL SPACE ACCESS REFER TO DETAIL 28A.4.31 AND STRUCTURAL DRAWINGS.
4. STAINLESS STEEL COMMERCIAL GRADE ISLAND COUNTER WITH OPEN SHELVING BELOW, 8' 0".
5. FIRE RISER LOCATION. REFER TO FIRE PROTECTION DRAWINGS.
6. CORNER GUARD. REFER TO FINISH SCHEDULE FOR ADDITIONAL INFORMATION.
7. ACCESSIBLE ROOM TO HAVE THE FOLLOWING COMMUNICATION FEATURES: AUDIBLE & VISUAL FIRE ALARM WARNING, CARBON MONOXIDE ALARM, DOOR ALERTING DEVICE. REFER TO FIRE ALARM AND ELECTRICAL PLANS FOR ADDITIONAL INFORMATION.

GENERAL NOTES

1. REFER TO SHEET A-9.00 FOR WALL TYPES.
2. PER CBC 2019, SECTION 11B-806.2.3.1 PROVIDE CLEAR SPACE UNDER BED IN MOBILITY FEATURE ROOMS FOR A PERSONAL LIFT DEVICE.

LEGEND

- 101 DOOR TYP NUMBER. REFER TO DOOR SCHEDULE.
- F WINDOW TYPE. REFER TO WINDOW SCHEDULE.
- F.E.C. FIRE EXTINGUISHER CABINET.
- I INTERIOR WINDOW SYMBOL/TYPE.
- A EXTERIOR WINDOW SYMBOL/TYPE.
- 1-HOUR RATED WALL FIRE PROTECTION.

CRAWL SPACE VENTILATION CALC - RTP

VENTILATION AREA FOR CRAWL SPACES WITH COVERED FLOORS PER CBC 1202.4.1.2

1 / 1500 SF = REQUIRED VENTILATION
4,588 / 1500 = 3.06 SF

1 VENT @ 1.5' x 6" = 1.5 SF
1 ACCESS VENT @ 2' x 1.5' = 3SF
PROVIDED VENTILATION 4.5SF
4.5SF > 3.06 SF



48 east holly street
pasadena, ca 91103
tel: 626.793.9805 fax: 626.793.9807



COUNTY OF
LOS ANGELES

OLIVE VIEW-UCLA
MEDICAL CENTER
RESTORATIVE CARE
VILLAGE
PACKAGE A

BUILDING SUBMITTAL

14445 OLIVE VIEW DRIVE
SYLMAR, CA 91342

AGENCY STAMP


AGENCY NUMBER	Approver
ISSUE/REVISION	
DESIGN DEVELOPMENT	02-06-2020
CD50	03-12-2020
PLAN CHECK	04-02-2020
BACK CHECK	05-27-2020
REVISIONS	07-13-2020
REVISIONS	08-14-2020
ADDITIONAL SCI REVISIONS	09-04-2020
RFI-240	
BULLETIN 12	01-29-2021

PROJECT DATA	
DATE	01/28/20
ARCHITECT	Designer
CHECKED BY	Checker
DRAWN BY	Author
PROJECT NO.	20190002


SHEET TITLE
RTP A - FIRST & SECOND FLOOR
PLANS

SHEET NO.

A-2.10A

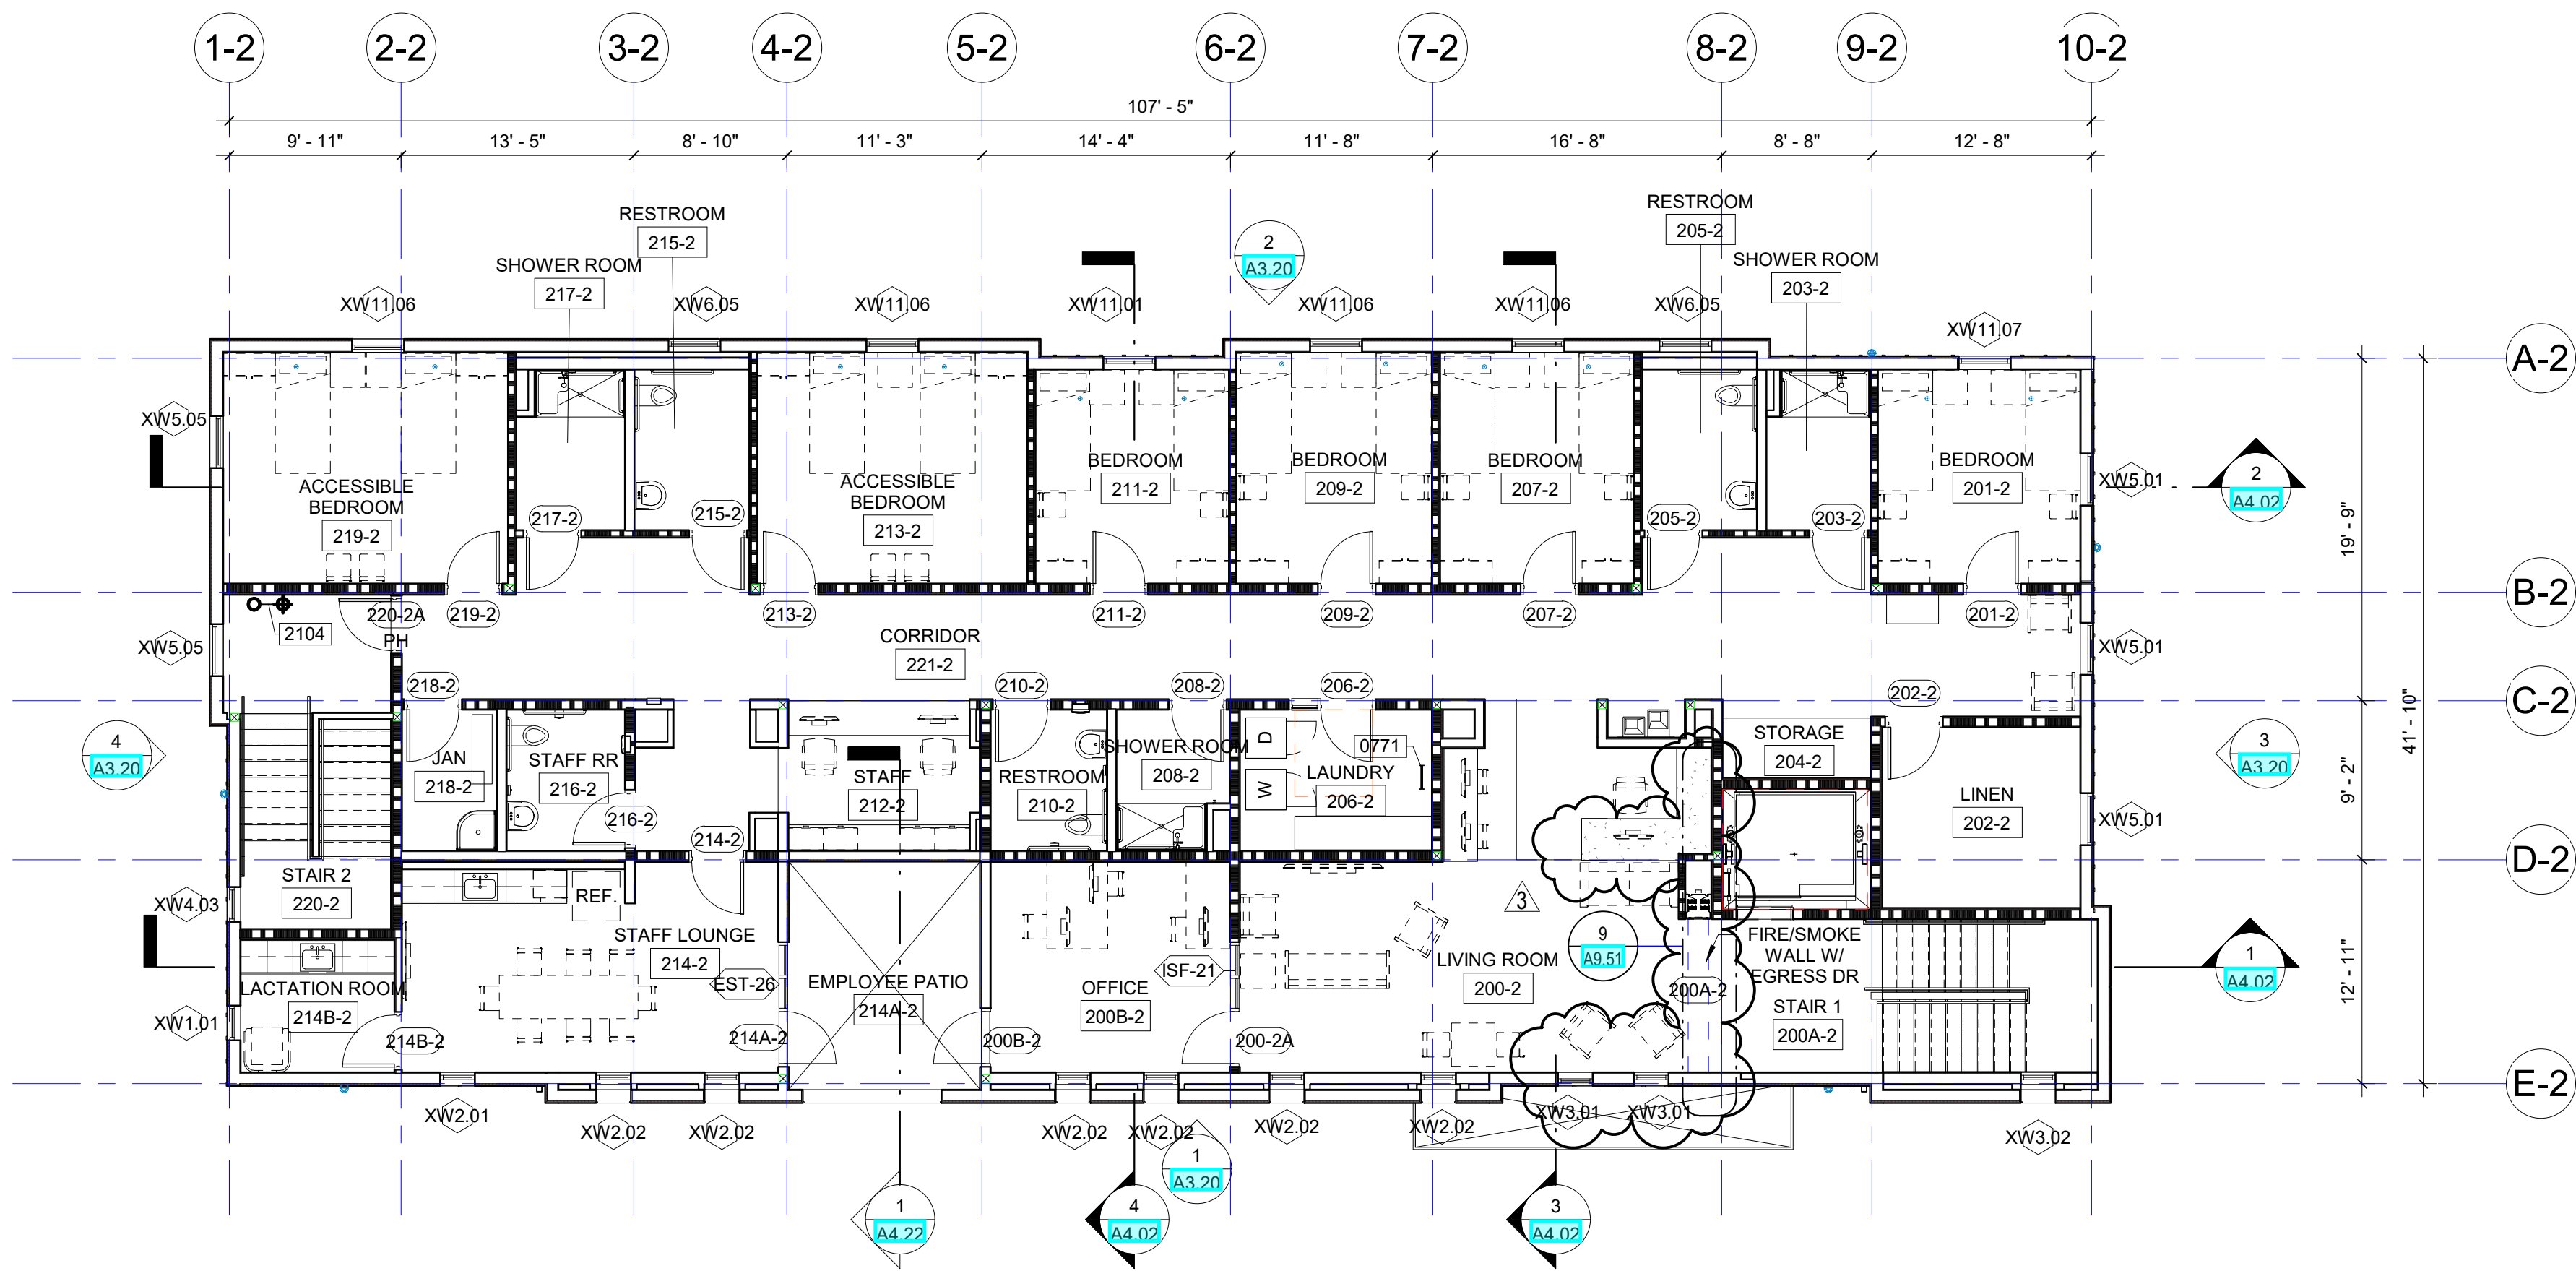


2 RTP - SECOND FLOOR PLAN
1/8" = 1'-0"

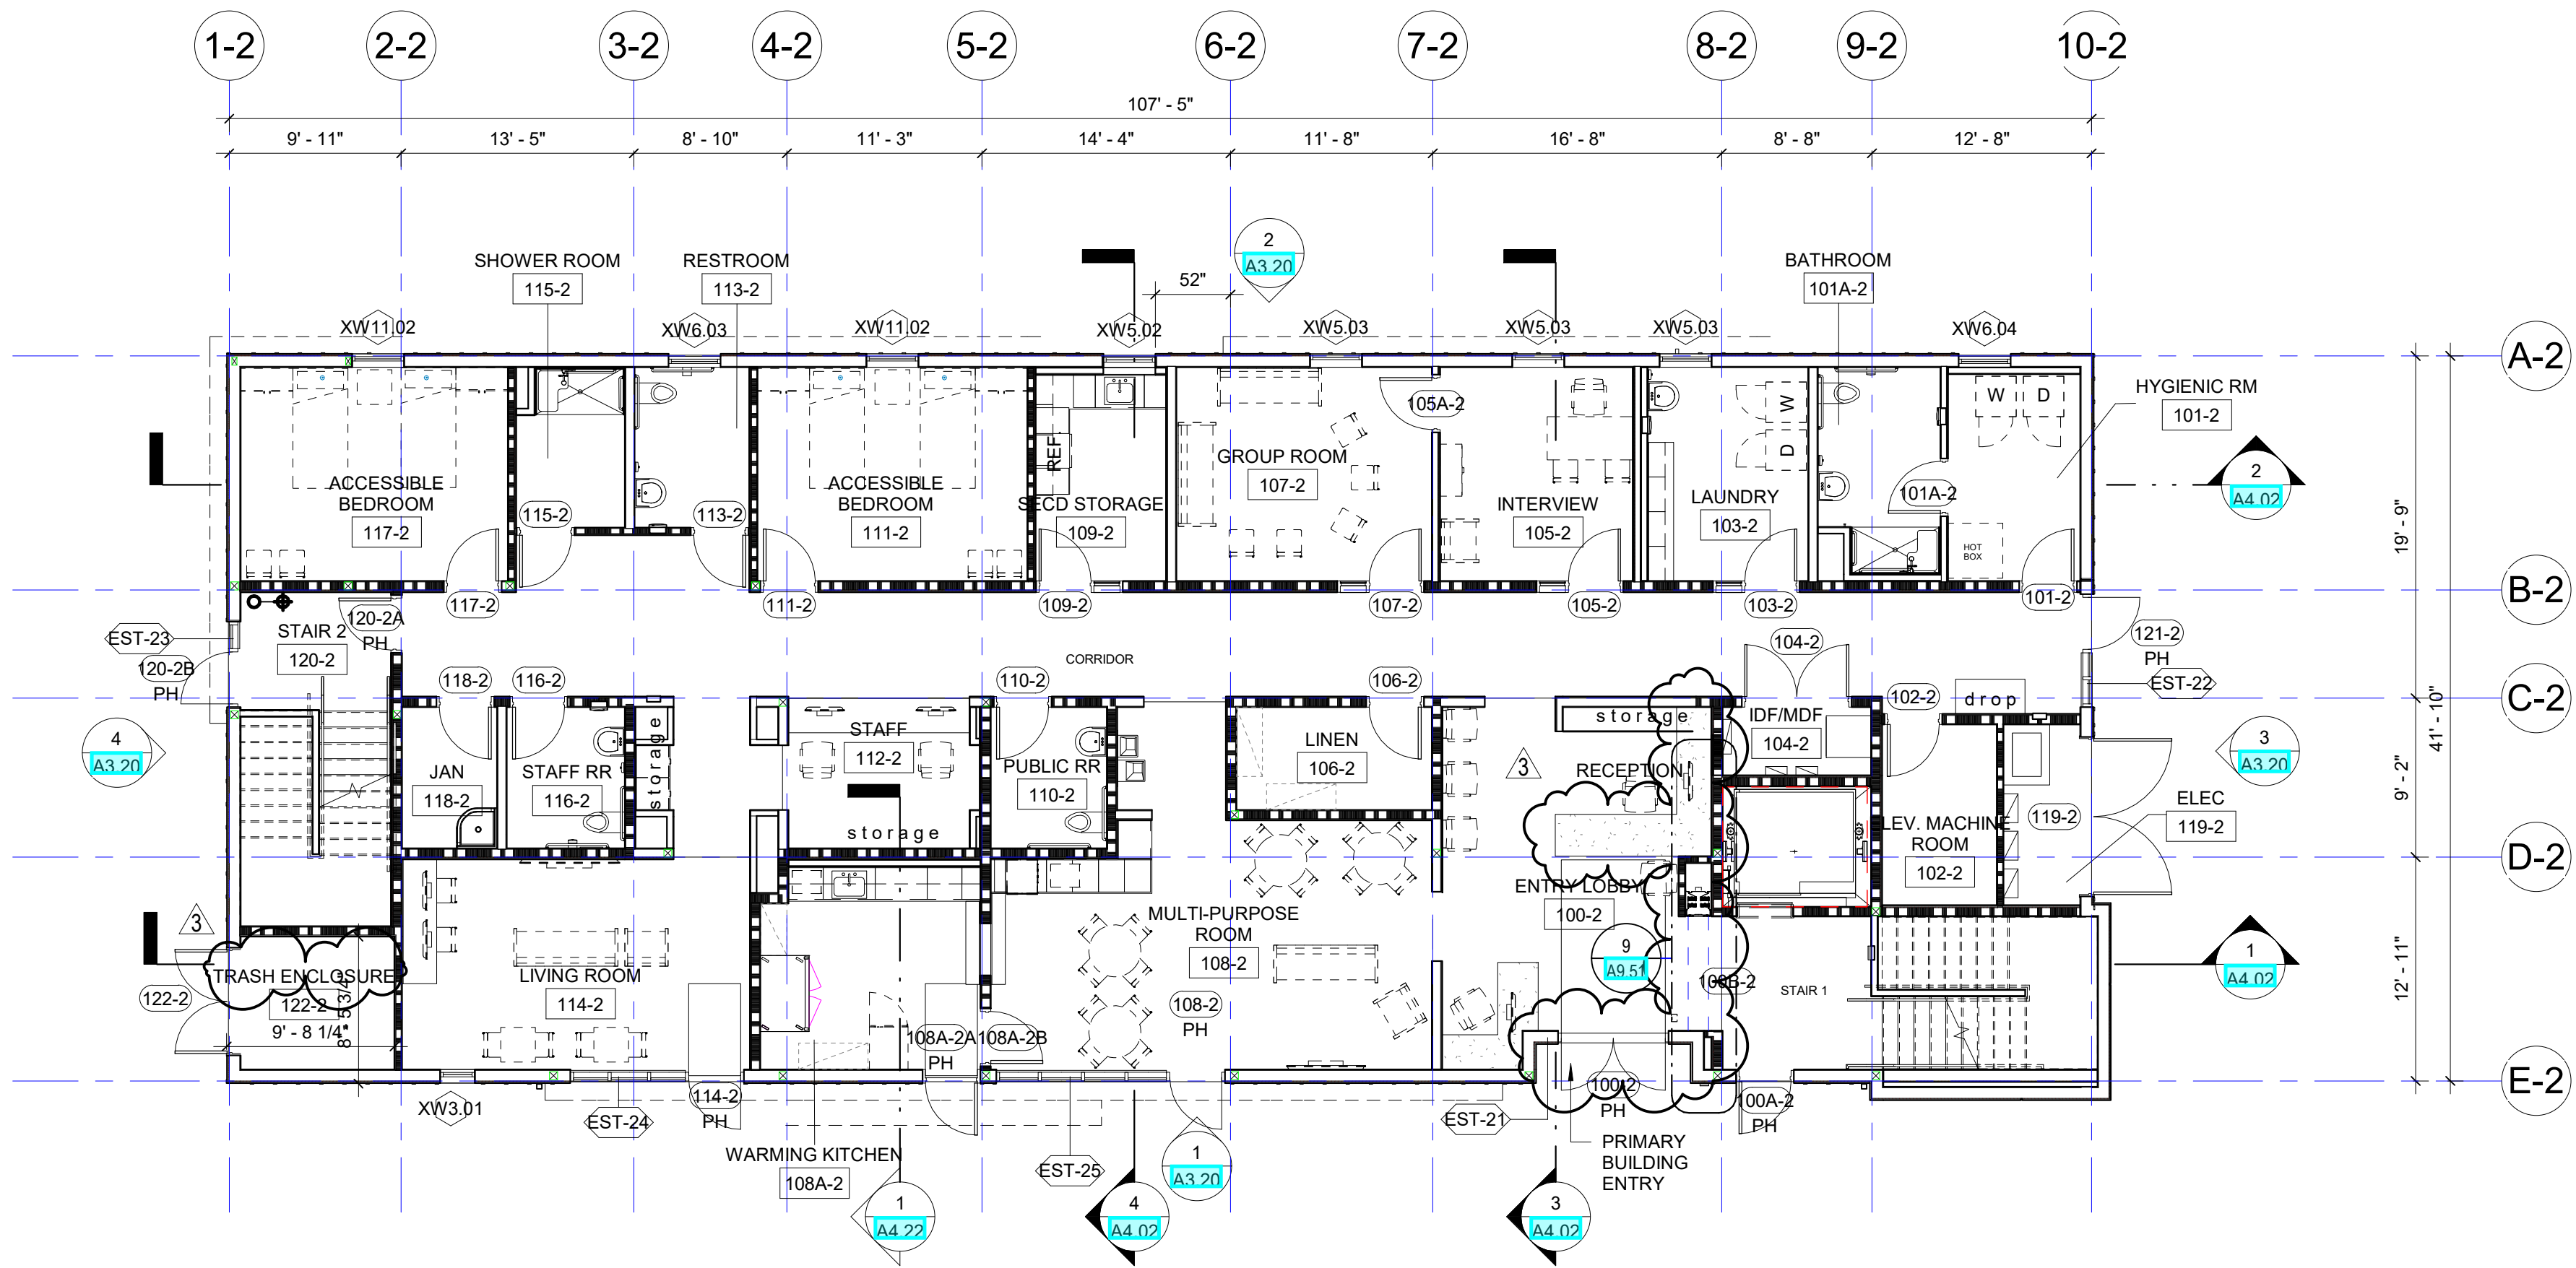

1 RTP - FIRST FLOOR PLAN
1/8" = 1'-0"

GENERAL NOTES


- N.I.C. UTILITY ITEMS SHOWN IN DASH. CONTRACTOR TO PROVIDE CONNECTIONS AS REQUIRED.
- ALL DIMENSIONS ARE FACE OF STUD AT INTERIOR WALLS. FACE OF STUD AT EXTERIOR WALLS. GRID LINES ARE LOCATED AT FACE OF STUD UNLESS NOTED OTHERWISE.
- ALL DOOR JAMBS TO BE FRAMED 4" FROM FACE OF STUD UNLESS NOTED OTHERWISE.
- ANNULAR SPACES AROUND PIPES, ELECTRIC CABLES, CONDUITS OR OTHER OPENINGS IN SOLE/BOTTOM PLATES AT EXTERIOR WALLS SHALL BE PROTECTED AGAINST THE PASSAGE OF RODENTS BY CLOSING SUCH OPENINGS WITH CEMENT MORTAR, CONCRETE MASONRY OR SIMILAR PRODUCTS.

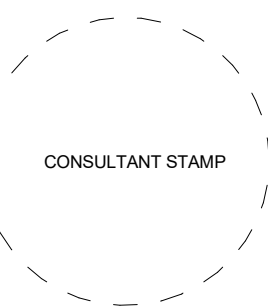

LEGEND

- 1-HR RATED WALL - SEE WALL TYPES
- 1-HR RATED FIRE RESISTANT EXTERIOR WALL - SEE WALL TYPES
- 1-HR RATED SMOKE BARRIER WALL - SEE WALL TYPES
- NON-RATED WALL - SEE WALL TYPES
- WINDOW TYPE - SEE SCHEDULE A8.10
- STOREFRONT TYPE - SEE SHEET A8.10
- DOOR TYPE - SEE SCHEDULE A8.11
- WALL TYPE - SEE SHEET A8.20
- FINISHES - SEE SHEETS A8.12 & A8.13
- MATCH LINE 1/1 A101
- FIRE SPRINKLER RISER - 1ST FLOOR
- FIRE SPRINKLER RISER - 2ND FLOOR
- LINE OF WALL OR CANOPY ABOVE
- 30" X 48" CLR. SPACE (AREA OF REFUGE)
- 48" X 60" CLR. SPACE
- 5'-0" Ø CLR. SPACE
- FLOOR DRAIN
- EXIT SIGN. SEE ELECTRICAL DWG.
- DOOR CLEARANCE: 24" Exterior, 18" Interior


KEY PLAN

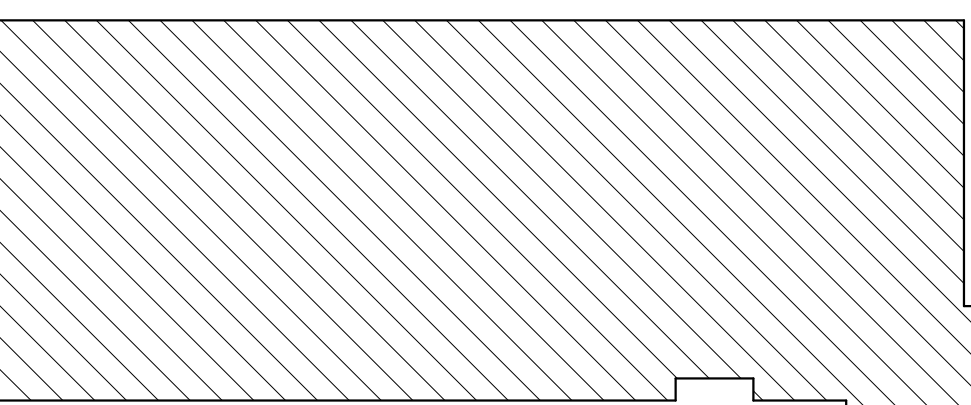

RANCHO LOS AMIGOS NATIONAL REHABILITATION CENTER

7601 E. IMPERIAL HIGHWAY, DOWNEY, CA 90242

PROJECT NO. 19883

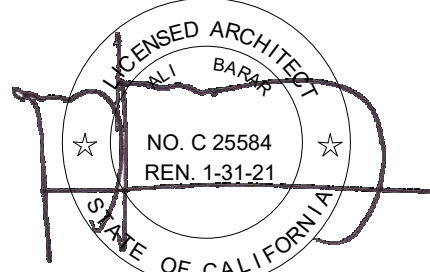

The ideas and designs represented herein and this drawing, all prepared by Gonzalez Goodale Architects are for the use solely with respect to this project and Gonzalez Goodale Architects shall retain all common law, statutory and other reserved rights including copyright and they shall not be used by others for any other purpose without written permission of Gonzalez Goodale Architects.

ISSUE DATE DESCRIPTION
5/15/20 FOUNDATION / BUILDING (PACKAGE B & C)

REVISION DATE DESCRIPTION
3 7/1/2020 POST ARCHITECTURAL APPROVAL



DRAWING TITLE

RTP - 1ST AND 2ND
FLOOR PLAN

A2.20

PLOT DATE: 7/10/2020 12:49:09 PM